

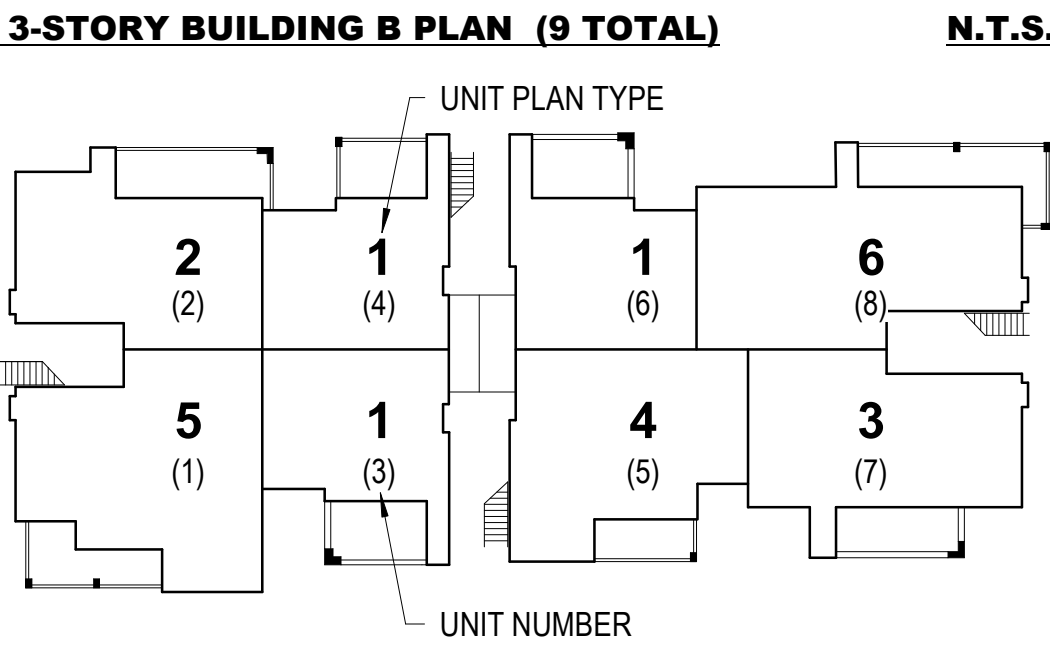


building type legend

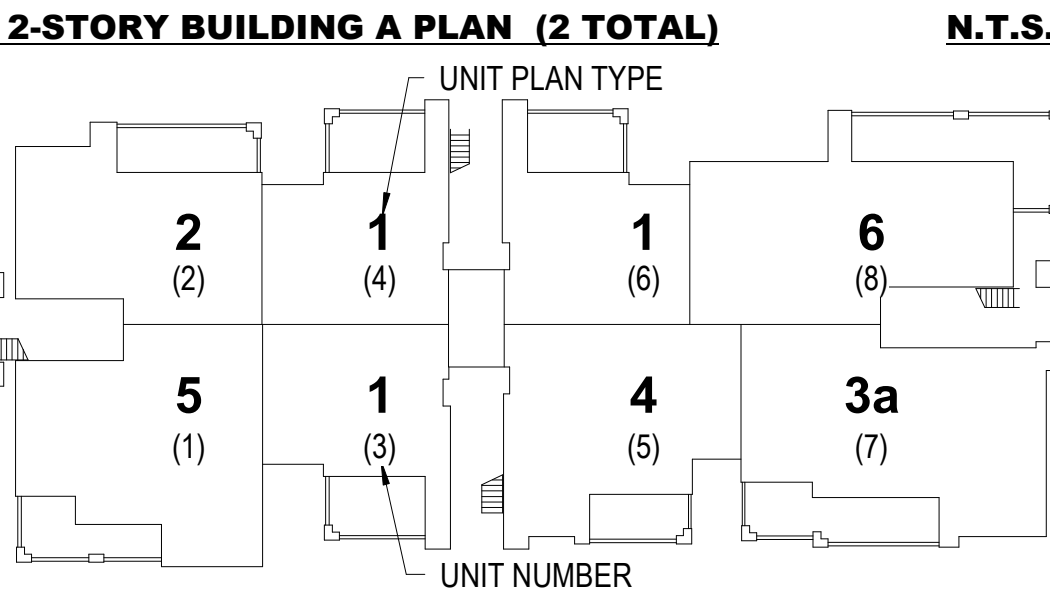

site plan legend

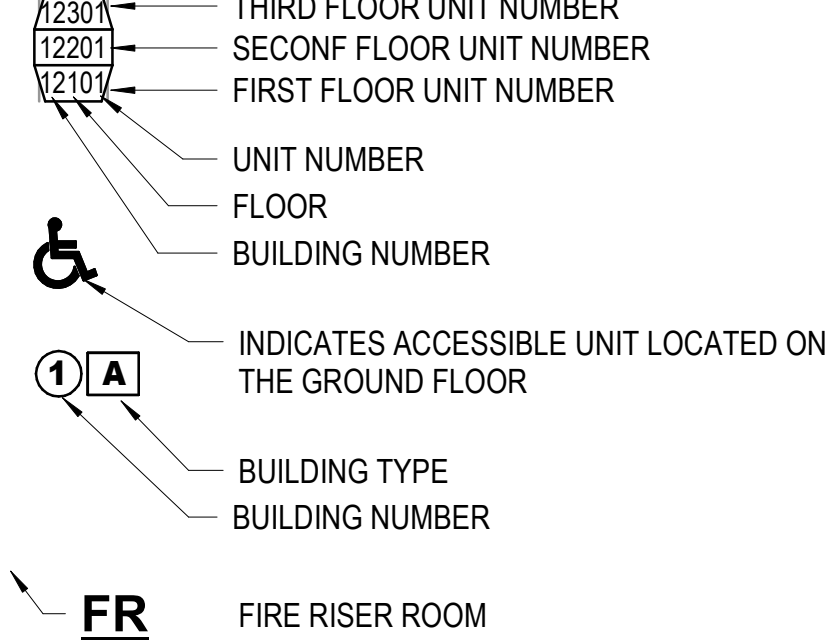

apartment type calcs:

320 APARTMENT UNITS TOTAL
2% OF WHICH SHALL BE ACCESSIBLE UNITS
320 x 2% = 6.4 THEREFORE (7) ACCESSIBLE UNITS ARE REQUIRED.
ALL OTHER FIRST FLOOR UNITS SHALL BE FULLY ADAPTABLE TO UNITS.

SEE ARCHITECTURAL FLOOR PLANS FOR UNIT LOCATIONS WITHIN EACH BUILDING.

fire sprinkler notes


- FIRE SPRINKLERS:**
- REQUIRED SPRINKLER SYSTEM ALLOWED TO BE NFPA 13R ON MOST BUILDING.
 - DUE TO LIMITED FIRE TRUCK ACCESS AT BUILDINGS 1 AND 2 SPRINKLER SYSTEM SHALL BE NFPA 13.
- FIRE / SMOKE DETECTION / ALARM**
- SMOKE DETECTOR ONLY. BUILDING OCCUPANCY LESS THAN 300, BUILDING FULLY SPRINKLERED.
 - WATER FLOW AND TAMPER SWITCH OPERATION FOR EACH SPRINKLER RISER AS WELL AS THE MANUAL FIRE ALARM SYSTEM IN THE LEASING OFFICE (CLUBHOUSE) SHALL BE MONITORED OFF-SITE BY A U.L. LISTED FIRE ALARM MONITORING STATION.
 - THE WATERPROOF HORN/STROBE WATER FLOW NOTIFICATION DEVICE SHALL BE LOCATED ON EACH BUILDING NEAR THE FIRE SPRINKLER RISER ROOM.

NUMBER OF DWELLING UNITS				
BUILDING #	TOTAL UNITS	FULLY ACCESSIBLE UNITS	FULLY ADAPTABLE UNITS	ACCESSIBLE UNIT TYPE AND NUMBER
BUILDING 1	16	0	8	
BUILDING 2	24	0	8	
BUILDING 3	24	0	8	
BUILDING 4	24	1	7	5
BUILDING 5	16	0	8	
BUILDING 6	24	1	7	2
BUILDING 7	24	0	8	
BUILDING 8	24	0	8	
BUILDING 9	24	1	7	3
BUILDING 10	24	1	7	1
BUILDING 11	24	1	7	1
BUILDING 12	24	1	7	4
BUILDING 13	24	0	8	
BUILDING 14	24	1	7	6
Grand total: 14	320	7	105	

general notes

- COORDINATE WITH CIVIL AND LANDSCAPE.
- REFER TO GATE SCHEDULE FOR SIZE AND HARDWARE.

keynotes

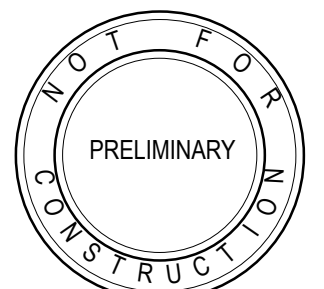

job
2415

date
03.06.25

revisions

HSL ENCANTADA MARKETPLACE
LUXURY APARTMENT HOMES
COMMON AREAS
ORO VALLEY, ARIZONA

site plan



x1.0


- ## keynotes

revisions


floor plan

a1.0

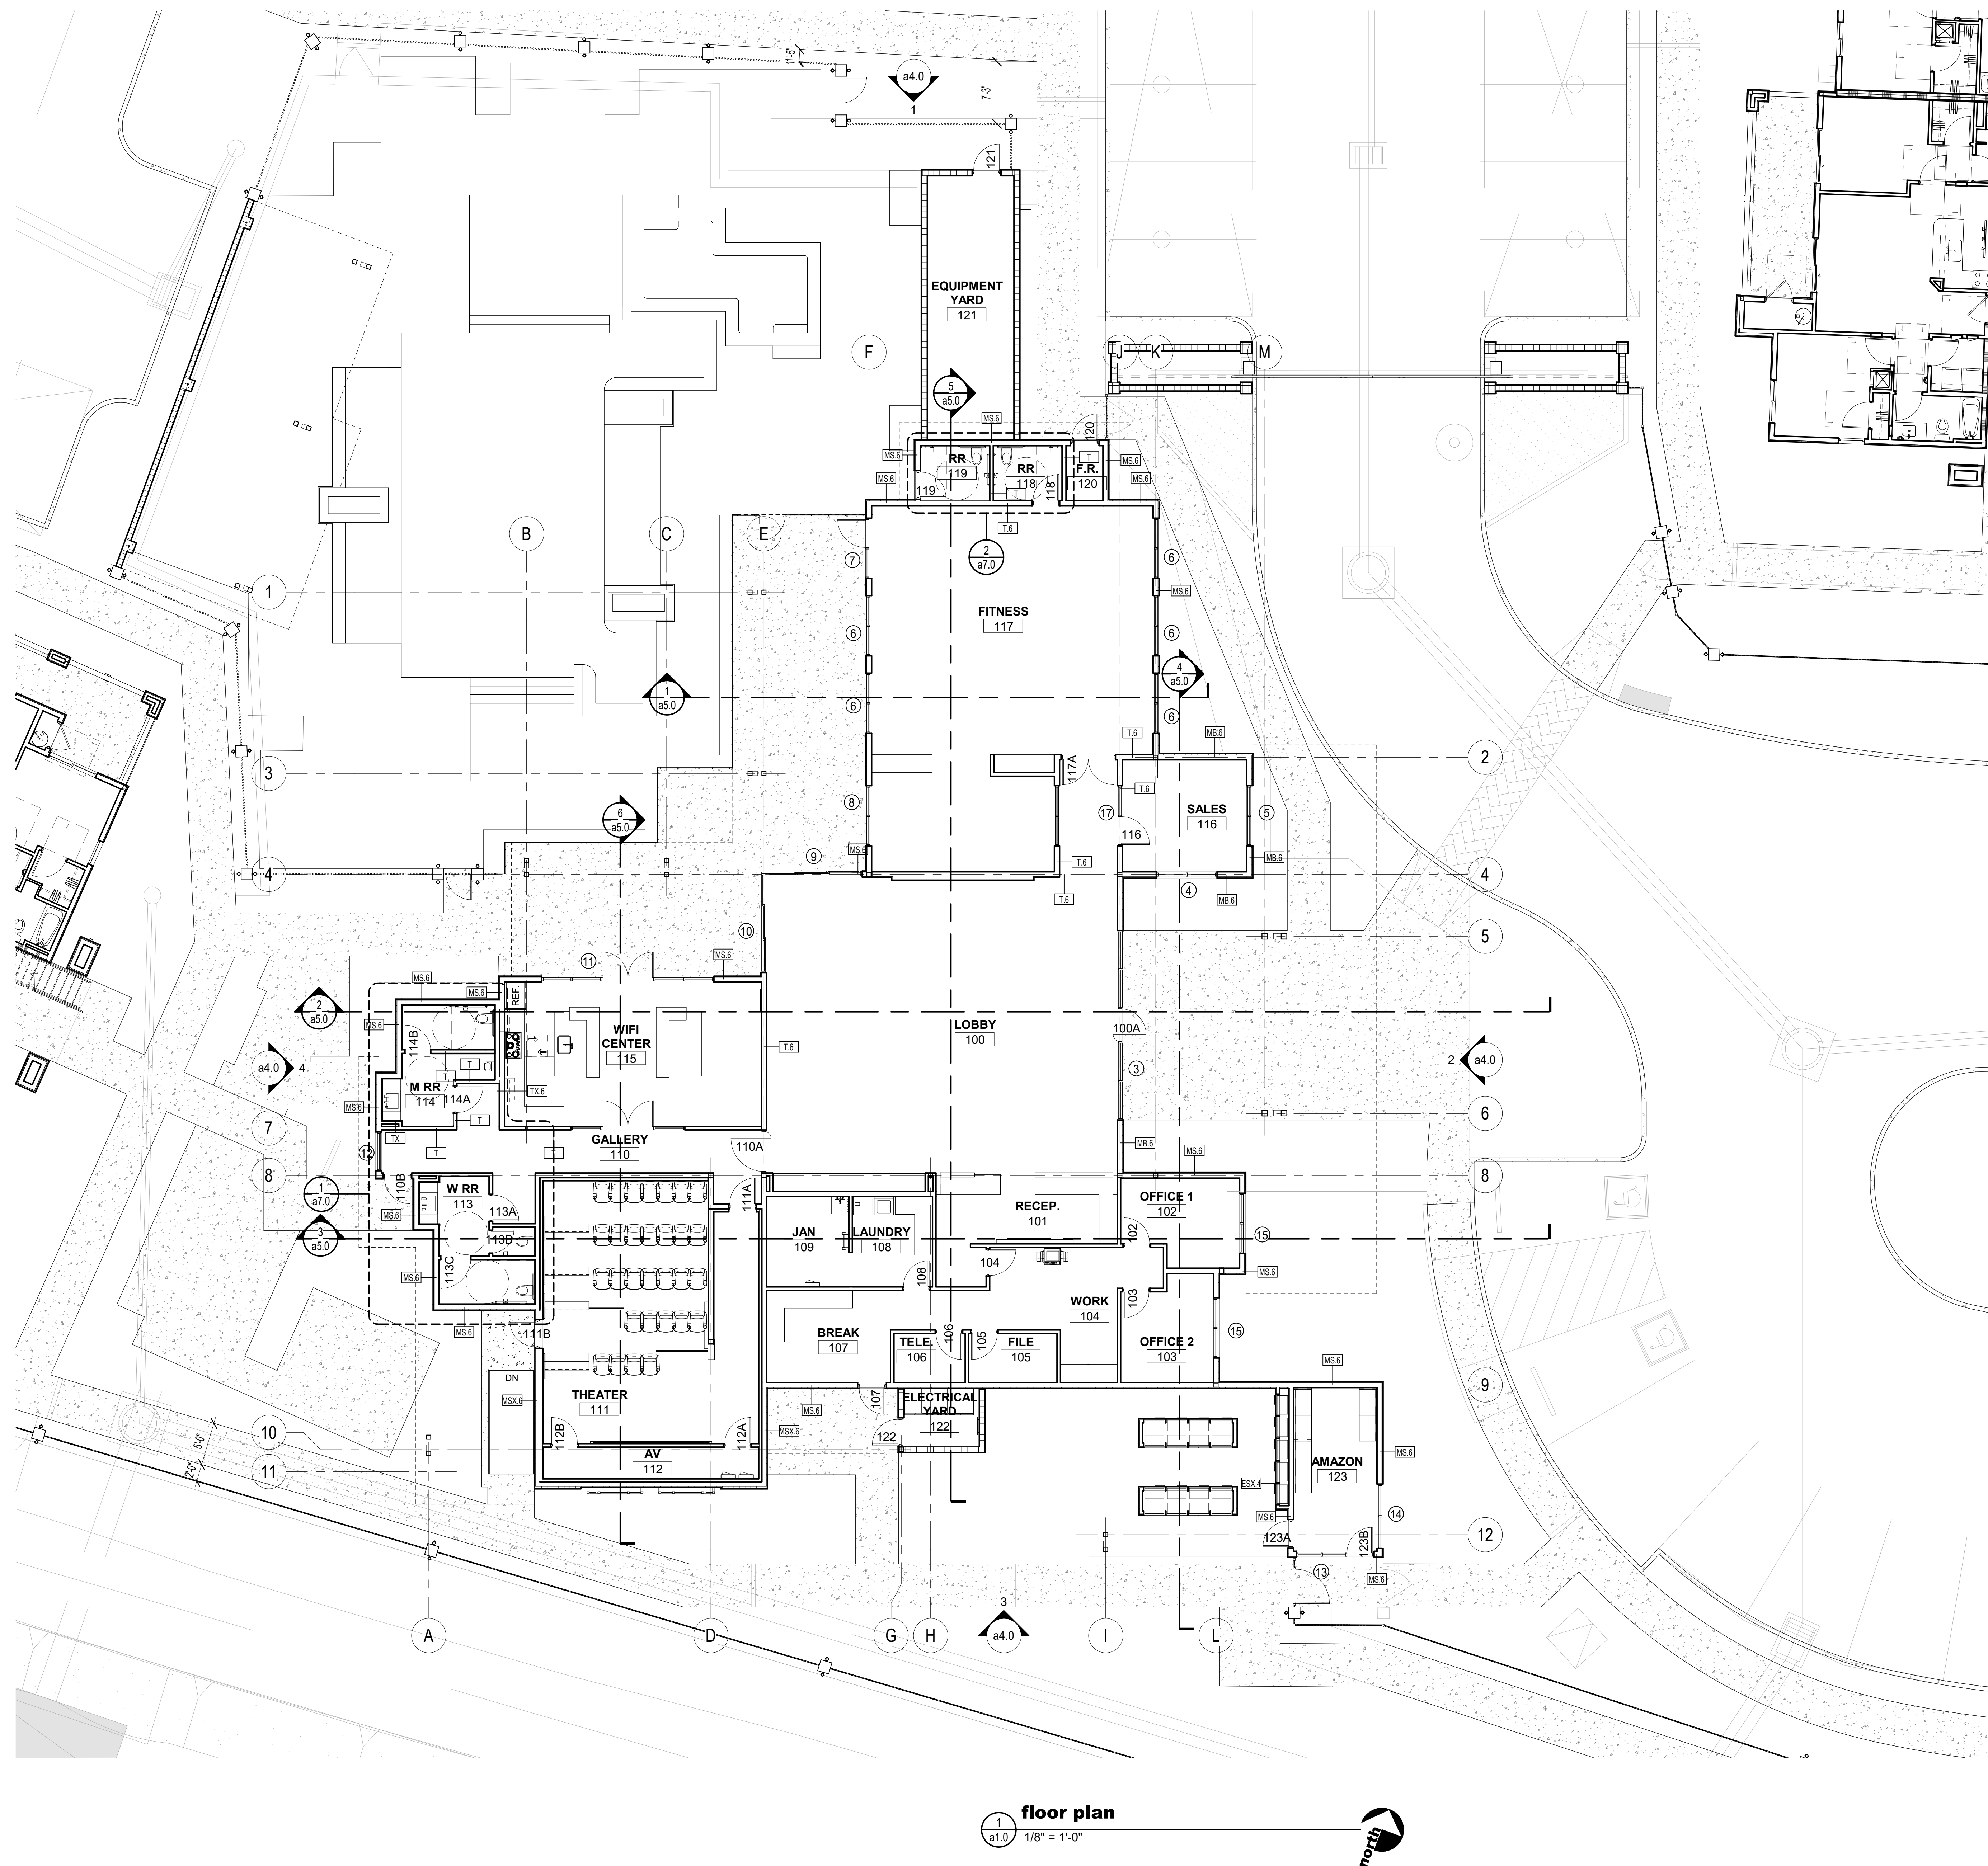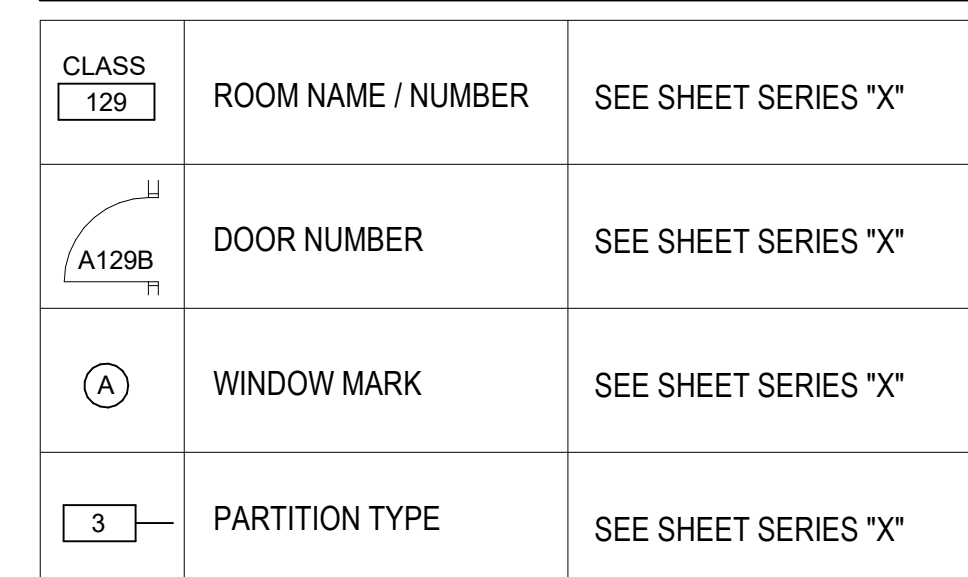

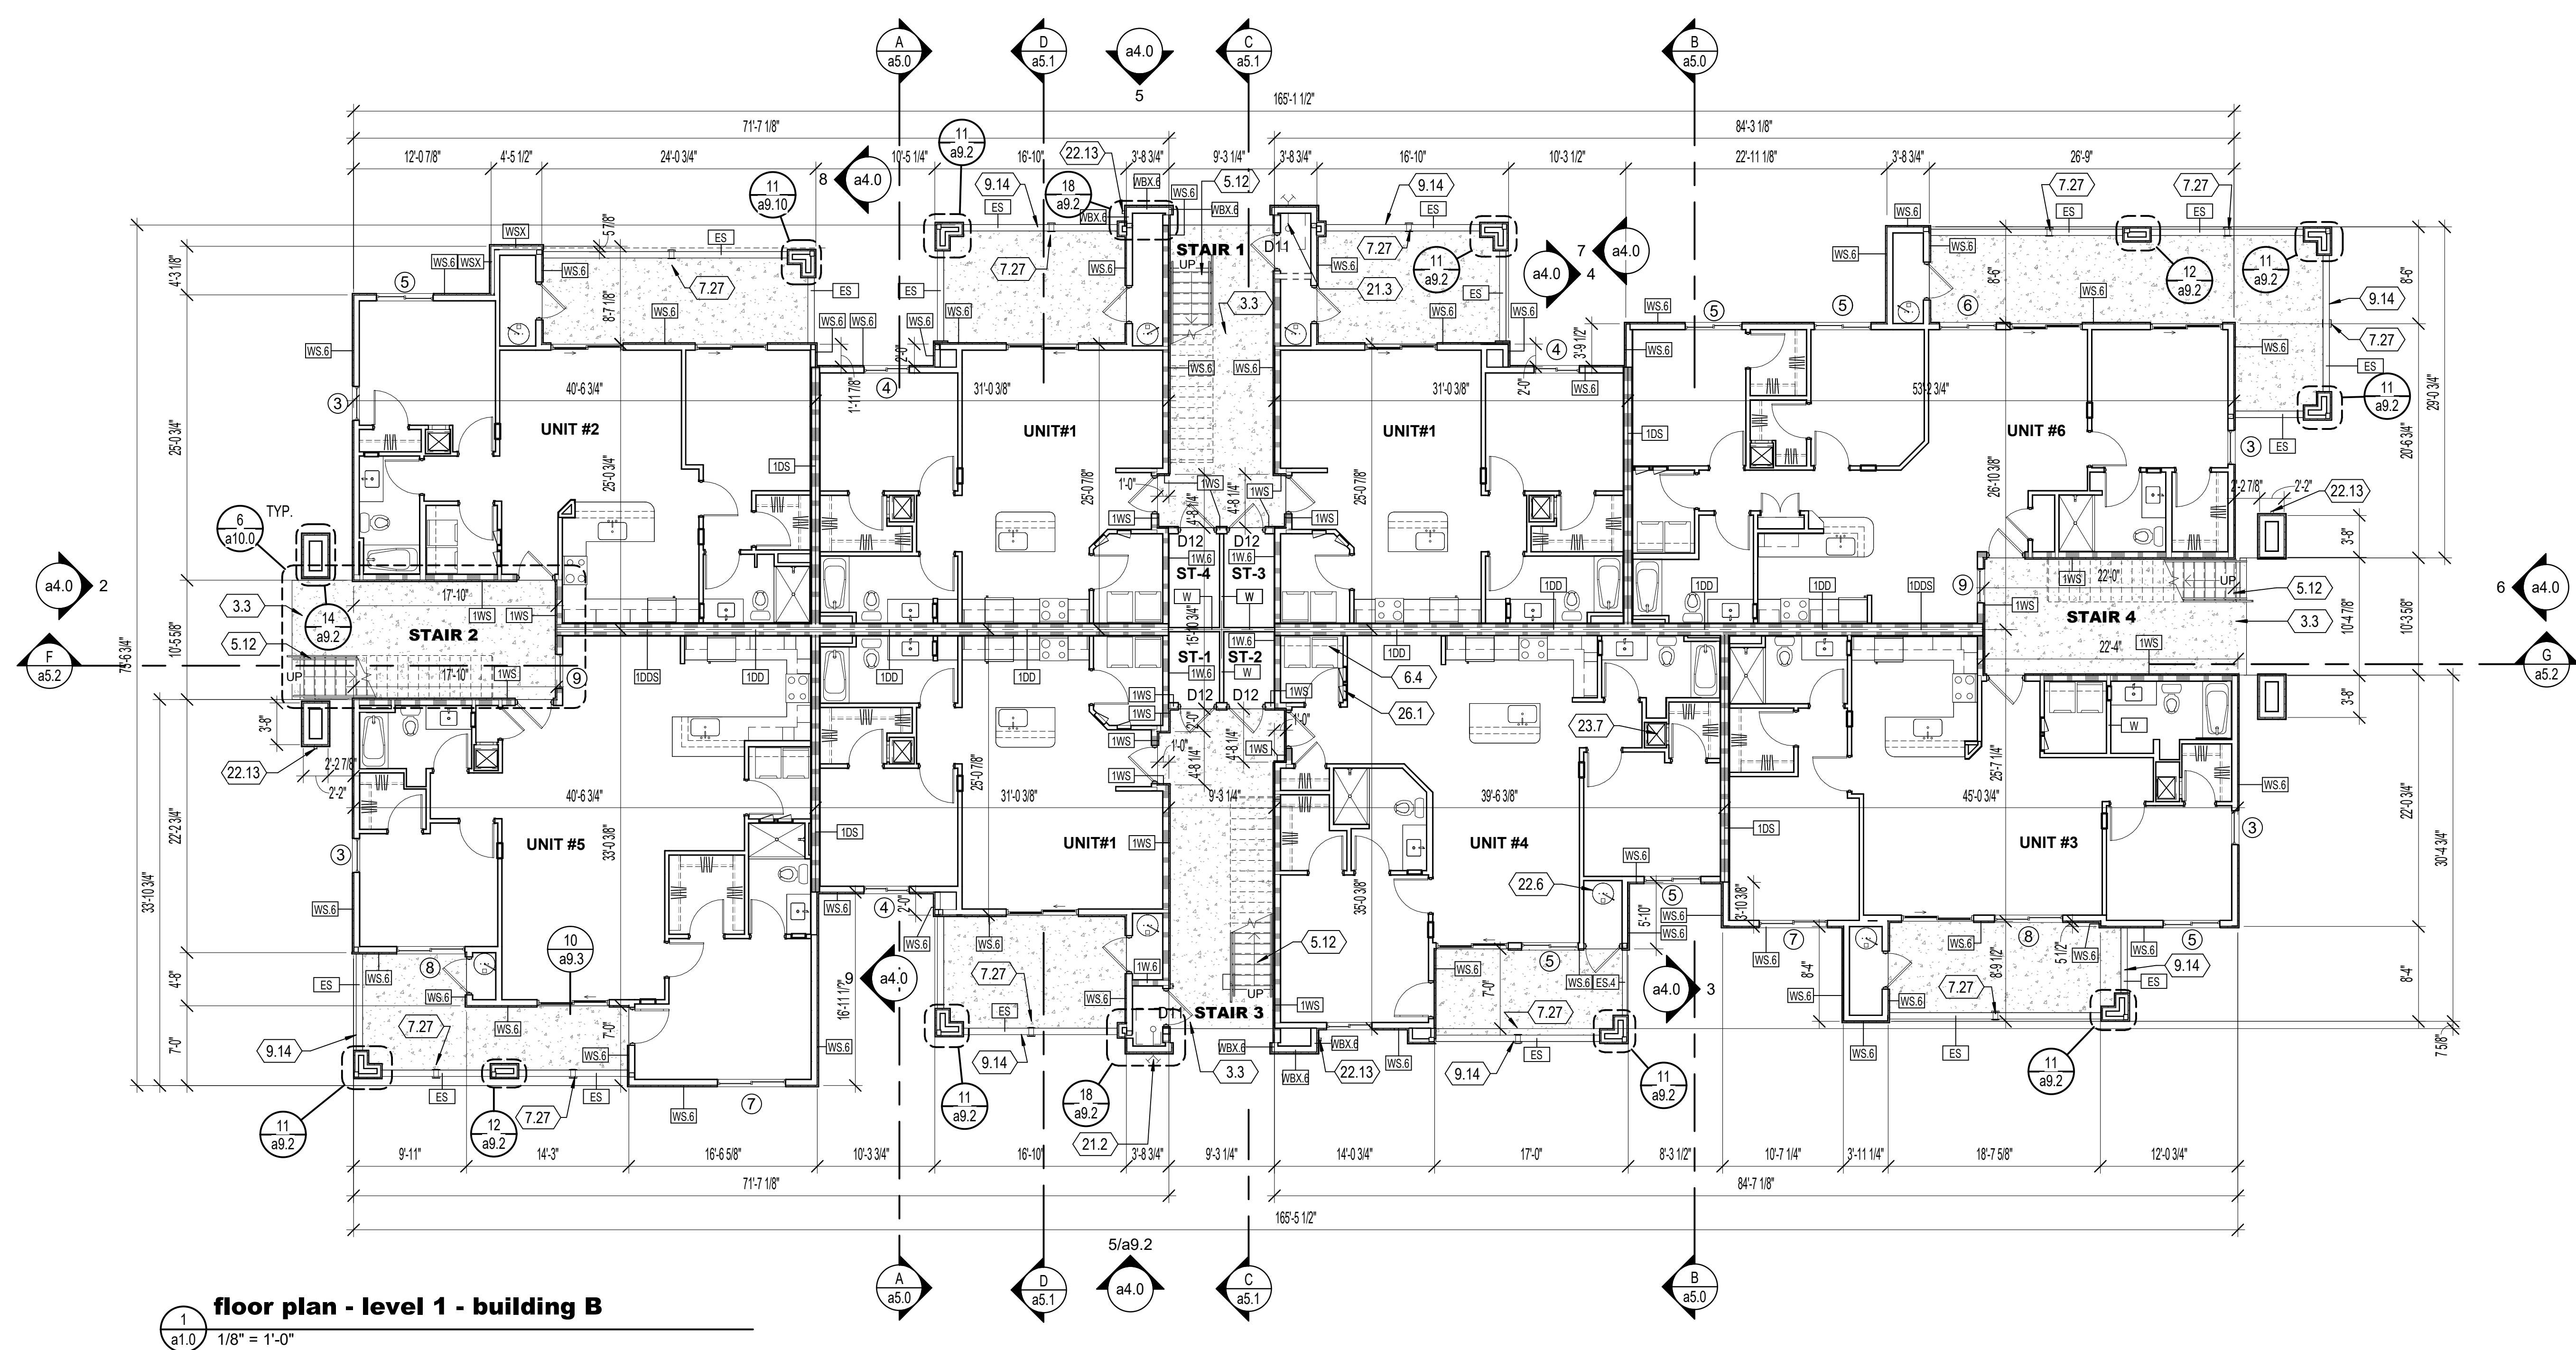

floor plan - level 1 - building B

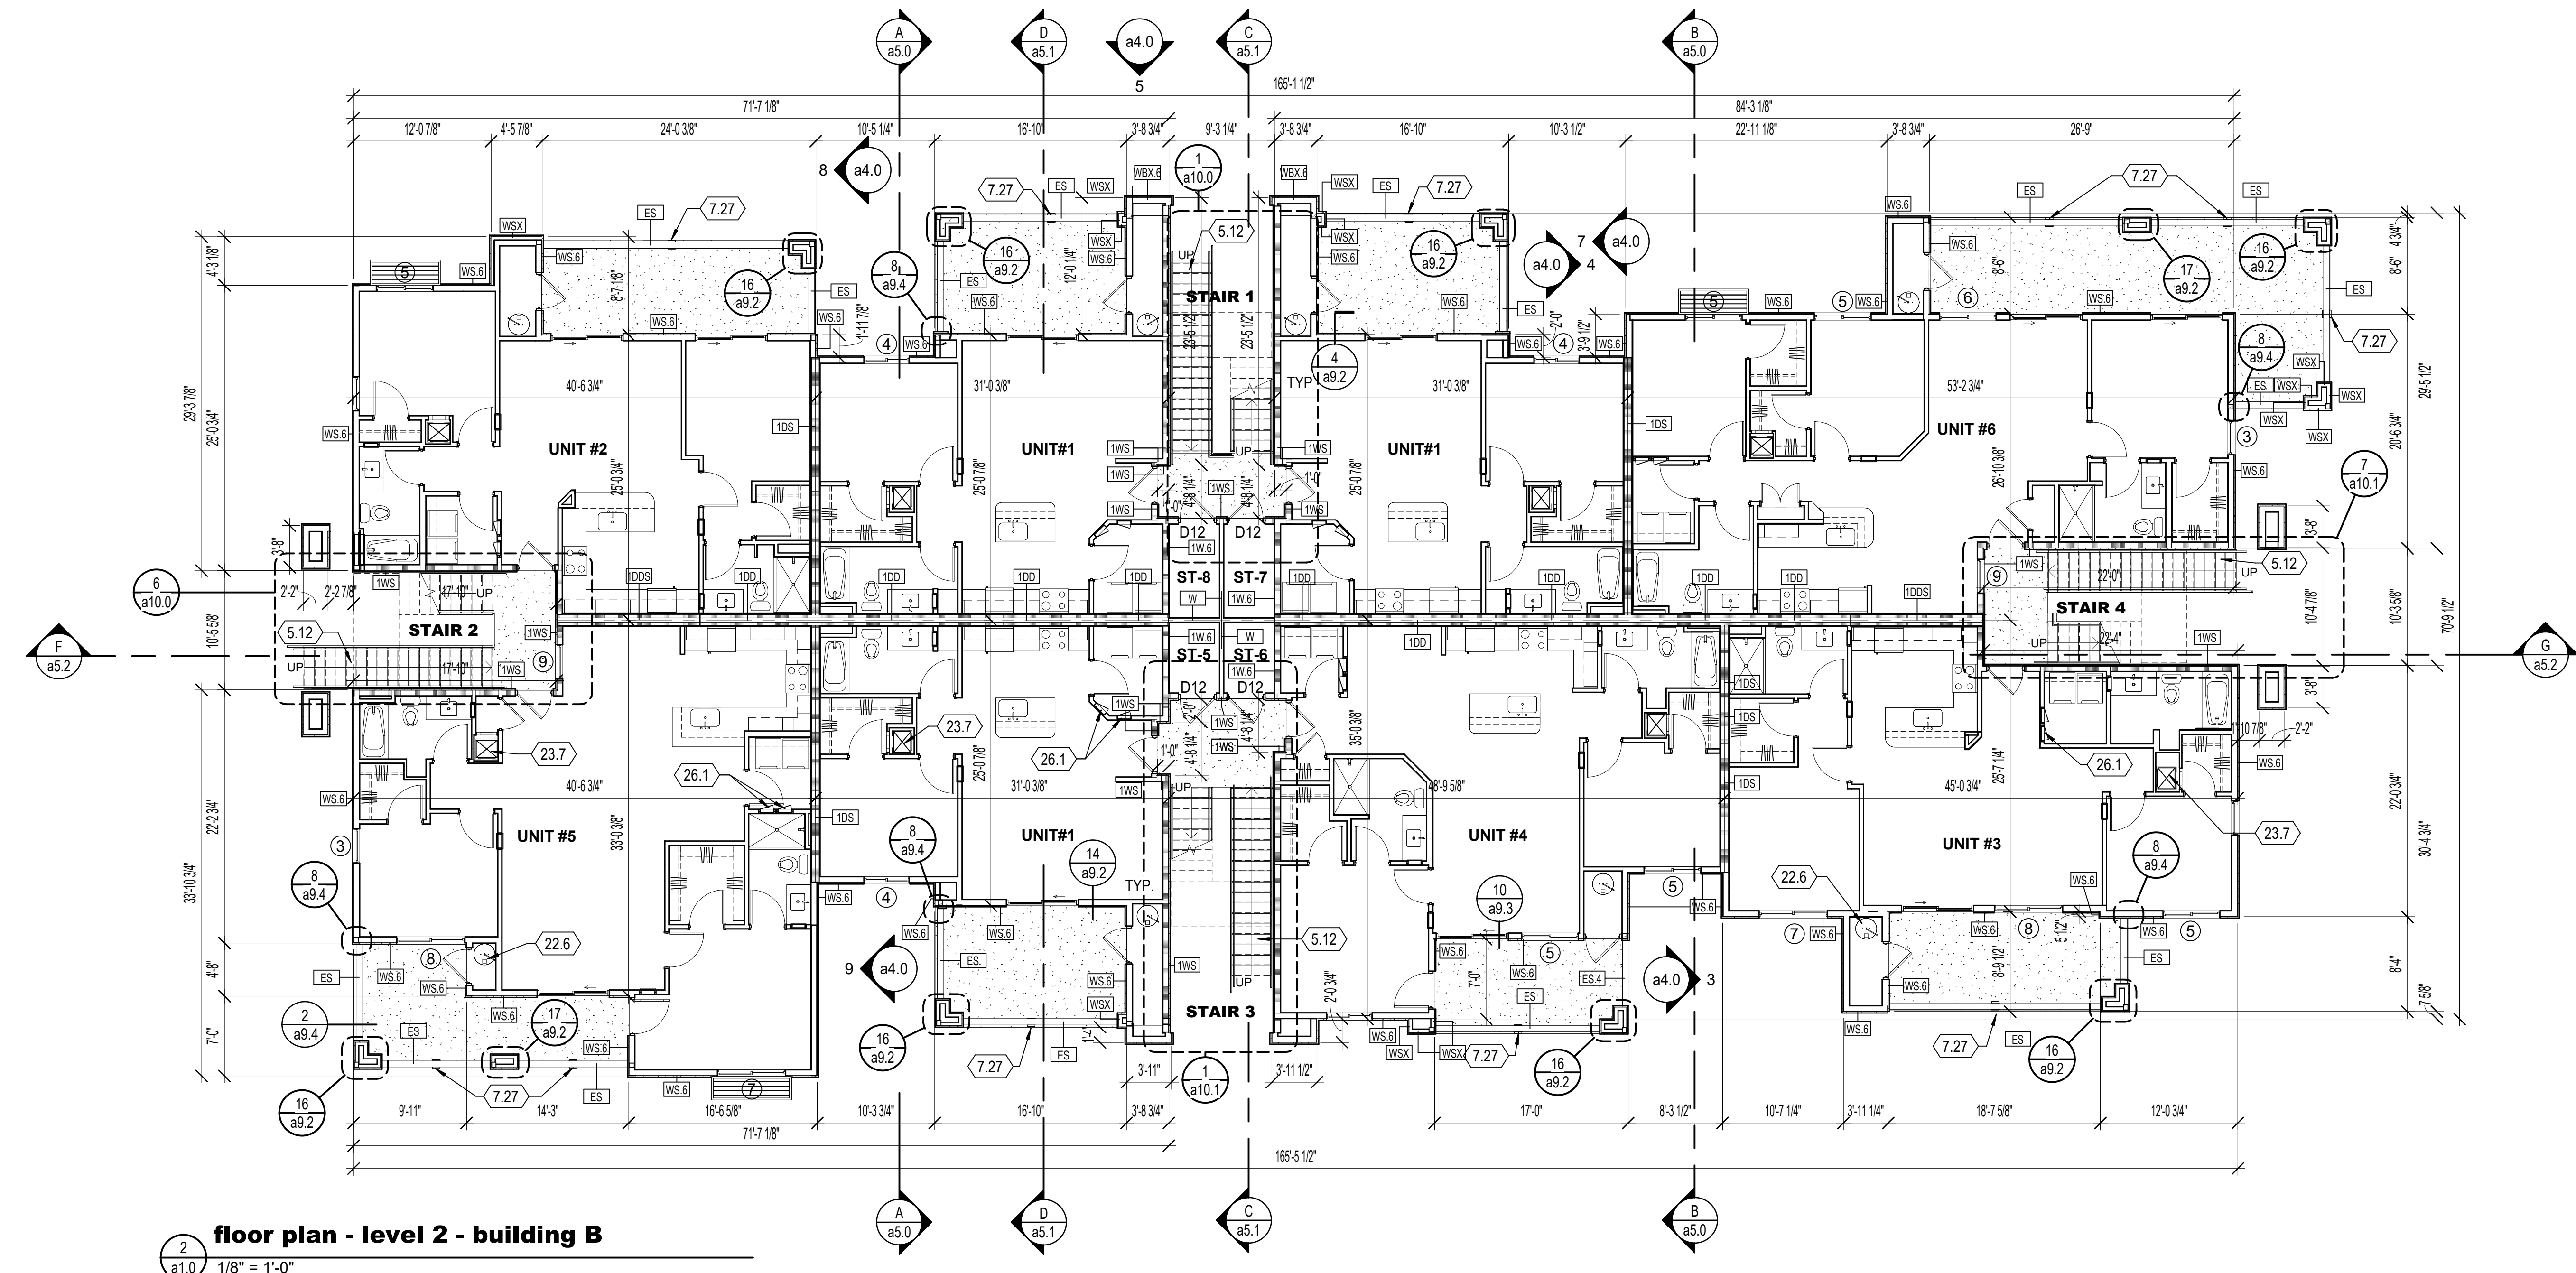

floor plan - level 2 - building B

floor plan general notes

- DO NOT SCALE DRAWINGS. COORDINATE ALL WORK BETWEEN ARCHITECTURAL, STRUCTURAL, CIVIL, MECHANICAL, PLUMBING, COMMUNICATIONS AND ELECTRICAL DRAWINGS. CONFLICTS SHALL BE BROUGHT TO THE ATTENTION OF THE ARCHITECT PRIOR TO THE IMPLEMENTATION OF WORK.
- REFER TO PLUMBING, MECHANICAL AND ELECTRICAL DRAWINGS FOR ALL APPLICABLE CODES FOR REQUIRED CLEARANCES OF EQUIPMENT.
- SEE SHEET a8.0 FOR WINDOW AND DOOR TYPES.
- SEE SHEET a9.0 FOR WALL TYPES.
- SEE DOOR SCHEDULE ON SHEET a8.1 FOR DOOR RATINGS.
- DIMENSIONS THIS SHEET ARE TO FACE OF SHEATHING WHICH MATCHES SLAB EDGE, AND TO CENTER LINE OF DEMISING WALL.
- REFER TO SHEET g1.2 FOR MOUNTING HEIGHTS, CLEARANCES, CABINET AND COUNTER REQUIREMENTS.
- REFER TO SHEET g3.0 FOR RATED CEILING/FLOOR ASSEMBLY OPTIONS. AND g3.1 FOR RATED WALL ASSEMBLY DETAILS

keynotes


- 3.3 CONCRETE SIDEWALK, REFER TO LANDSCAPE AND CIVIL.
- 5.12 PRE-ENGINEERED STEEL STAIR SYSTEM WITH CONCRETE TREADS AND STEEL GUARDRAILS AND HANDRAILS.
- 6.4 SHELF.
- 7.27 SCUPPER THROUGH PATIO WALL, 4" X 8".
- 9.14 STUCCO SYSTEM OVER WOOD FRAMED PARTIAL HEIGHT WALL.
- 21.2 FIRE DEPARTMENT CONNECTION.
- 21.3 ALTERNATE FIRE RISER LOCATION - REFER TO CIVIL SITE PLAN FOR CONNECTION LOCATION.
- 22.6 WATER HEATER, REFER TO PLUMBING.
- 22.13 RAIN WATER LEADER OUTLET.
- 23.7 HVAC UNIT - REFER TO MECHANICAL.
- 26.1 ELECTRICAL PANEL, REFER TO ELECTRICAL.

floor plan sheet legend

CLASS	ROOM NAME / NUMBER
129	
A129B	DOOR NUMBER
A	WINDOW MARK
3	PARTITION TYPE

WALL SCHEDULE

MARK	DESCRIPTION	WIDTH	STC RATING	FIRE RATING	UL#
1D	5/8" TYPE 'X' GWB, 1/2" RESILIENT CHANNEL, 2x4 WOOD STUDS, 1/2" AIR SPACE, 2x4 WOOD STUDS, 1/2" SOUND BOARD, 1/2" SHEAR PANEL, 5/8" TYPE 'X' GWB	8 7/8"	40	1HR	U340
1DD	5/8" TYPE 'X' GWB, 5/8" RESILIENT CHANNEL, 2x4 WOOD STUDS, 4 1/2" AIR SPACE, 2x4 WOOD STUDS, 5/8" SOUND BOARD, 5/8" TYPE 'X' GWB	1'-0 1/2"	40	1HR	U386
1DDs	5/8" TYPE 'X' GWB, 5/8" RESILIENT CHANNEL, 2x4 WOOD STUDS, 4 1/2" AIR SPACE, 2x4 WOOD STUDS, 5/8" SOUND BOARD, 5/8" TYPE 'X' GWB	1'-0 7/8"	40	1HR	U386
1DS	5/8" TYPE 'X' GWB, 1/2" RESILIENT CHANNEL, 2x4 WOOD STUDS, 1/2" AIR SPACE, 2x4 WOOD STUDS, 1/2" SOUND BOARD, 1/2" SHEAR PANEL, 5/8" TYPE 'X' GWB	8 7/8"	40	1HR	U340
1W.6	5/8" GWB, 2x6 WOOD STUD, 5/8" GWB	6 3/4"	N/A	1HR	U305
1WS	5/8" GYP BD, 2x6 WD FRAMING, BATT INSULATION, 3/8" 1/2" WOOD SHEATHING, WEATHER BARRIER, 1" RIGID INSULATION, STUCCO SYSTEM	7 7/8"	N/A	1HR	EER #382
ES	STUCCO SYSTEM, WEATHER BARRIER, 3/8" WOOD SHEATHING, 2x6 WD FRAMING, 3/8" WOOD SHEATHING, WEATHER BARRIER, STUCCO SYSTEM	6 3/4"	N/A	NR	N/A
ES.4	STUCCO SYSTEM, WEATHER BARRIER, 3/8" WOOD SHEATHING, 2x4 WD FRAMING, 3/8" WOOD SHEATHING, WEATHER BARRIER, STUCCO SYSTEM	5"	N/A	NR	N/A
ESW	STUCCO SYSTEM, 1" RIGID FOAM, WOOD SHEATHING, 2x6 WOOD STUD, 3/8" SHEATHING AT PARAPETS	8 3/8"	N/A	NR	N/A
W	5/8" GWB, 2x4 WOOD STUD, 5/8" GWB	4 3/4"	N/A	NR	N/A
W2	5/8" GWB, 2x4 WOOD STUD, SOUND BATTS, 5/8" GWB	4 3/4"	-	NR	N/A
W2	5/8" GWB, 2x4 WOOD STUD, 5/8" GWB	2 3/4"	N/A	NR	N/A
W.6	5/8" GWB, 2x6 WOOD STUD, 5/8" GWB	6 3/4"	N/A	NR	N/A
WBX.6	BRICK VENEER ON SCRATCH COAT, 1" RIGID FOAM, WOOD SHEATHING, 2x6 WOOD STUD, 5/8" GYPSUM BOARD INTERIOR SIDE.	8 1/2"	N/A	NR	N/A
WS.6	5/8" GYP BD, 2x6 WD FRAMING, BATT INSULATION, 3/8" 1/2" WOOD SHEATHING, WEATHER BARRIER, 1" RIGID INSULATION, STUCCO SYSTEM	7 7/8"	N/A	NR	N/A
WSX	STUCCO SYSTEM, WEATHER BARRIER, 1" RIGID INSULATION, 3/8" WOOD SHEATHING, 2x4 WOOD FRAMING	5 1/4"	N/A	NR	N/A
WX.6	5/8" GWB, 2x6 WOOD STUD	6 1/8"	N/A	NR	N/A

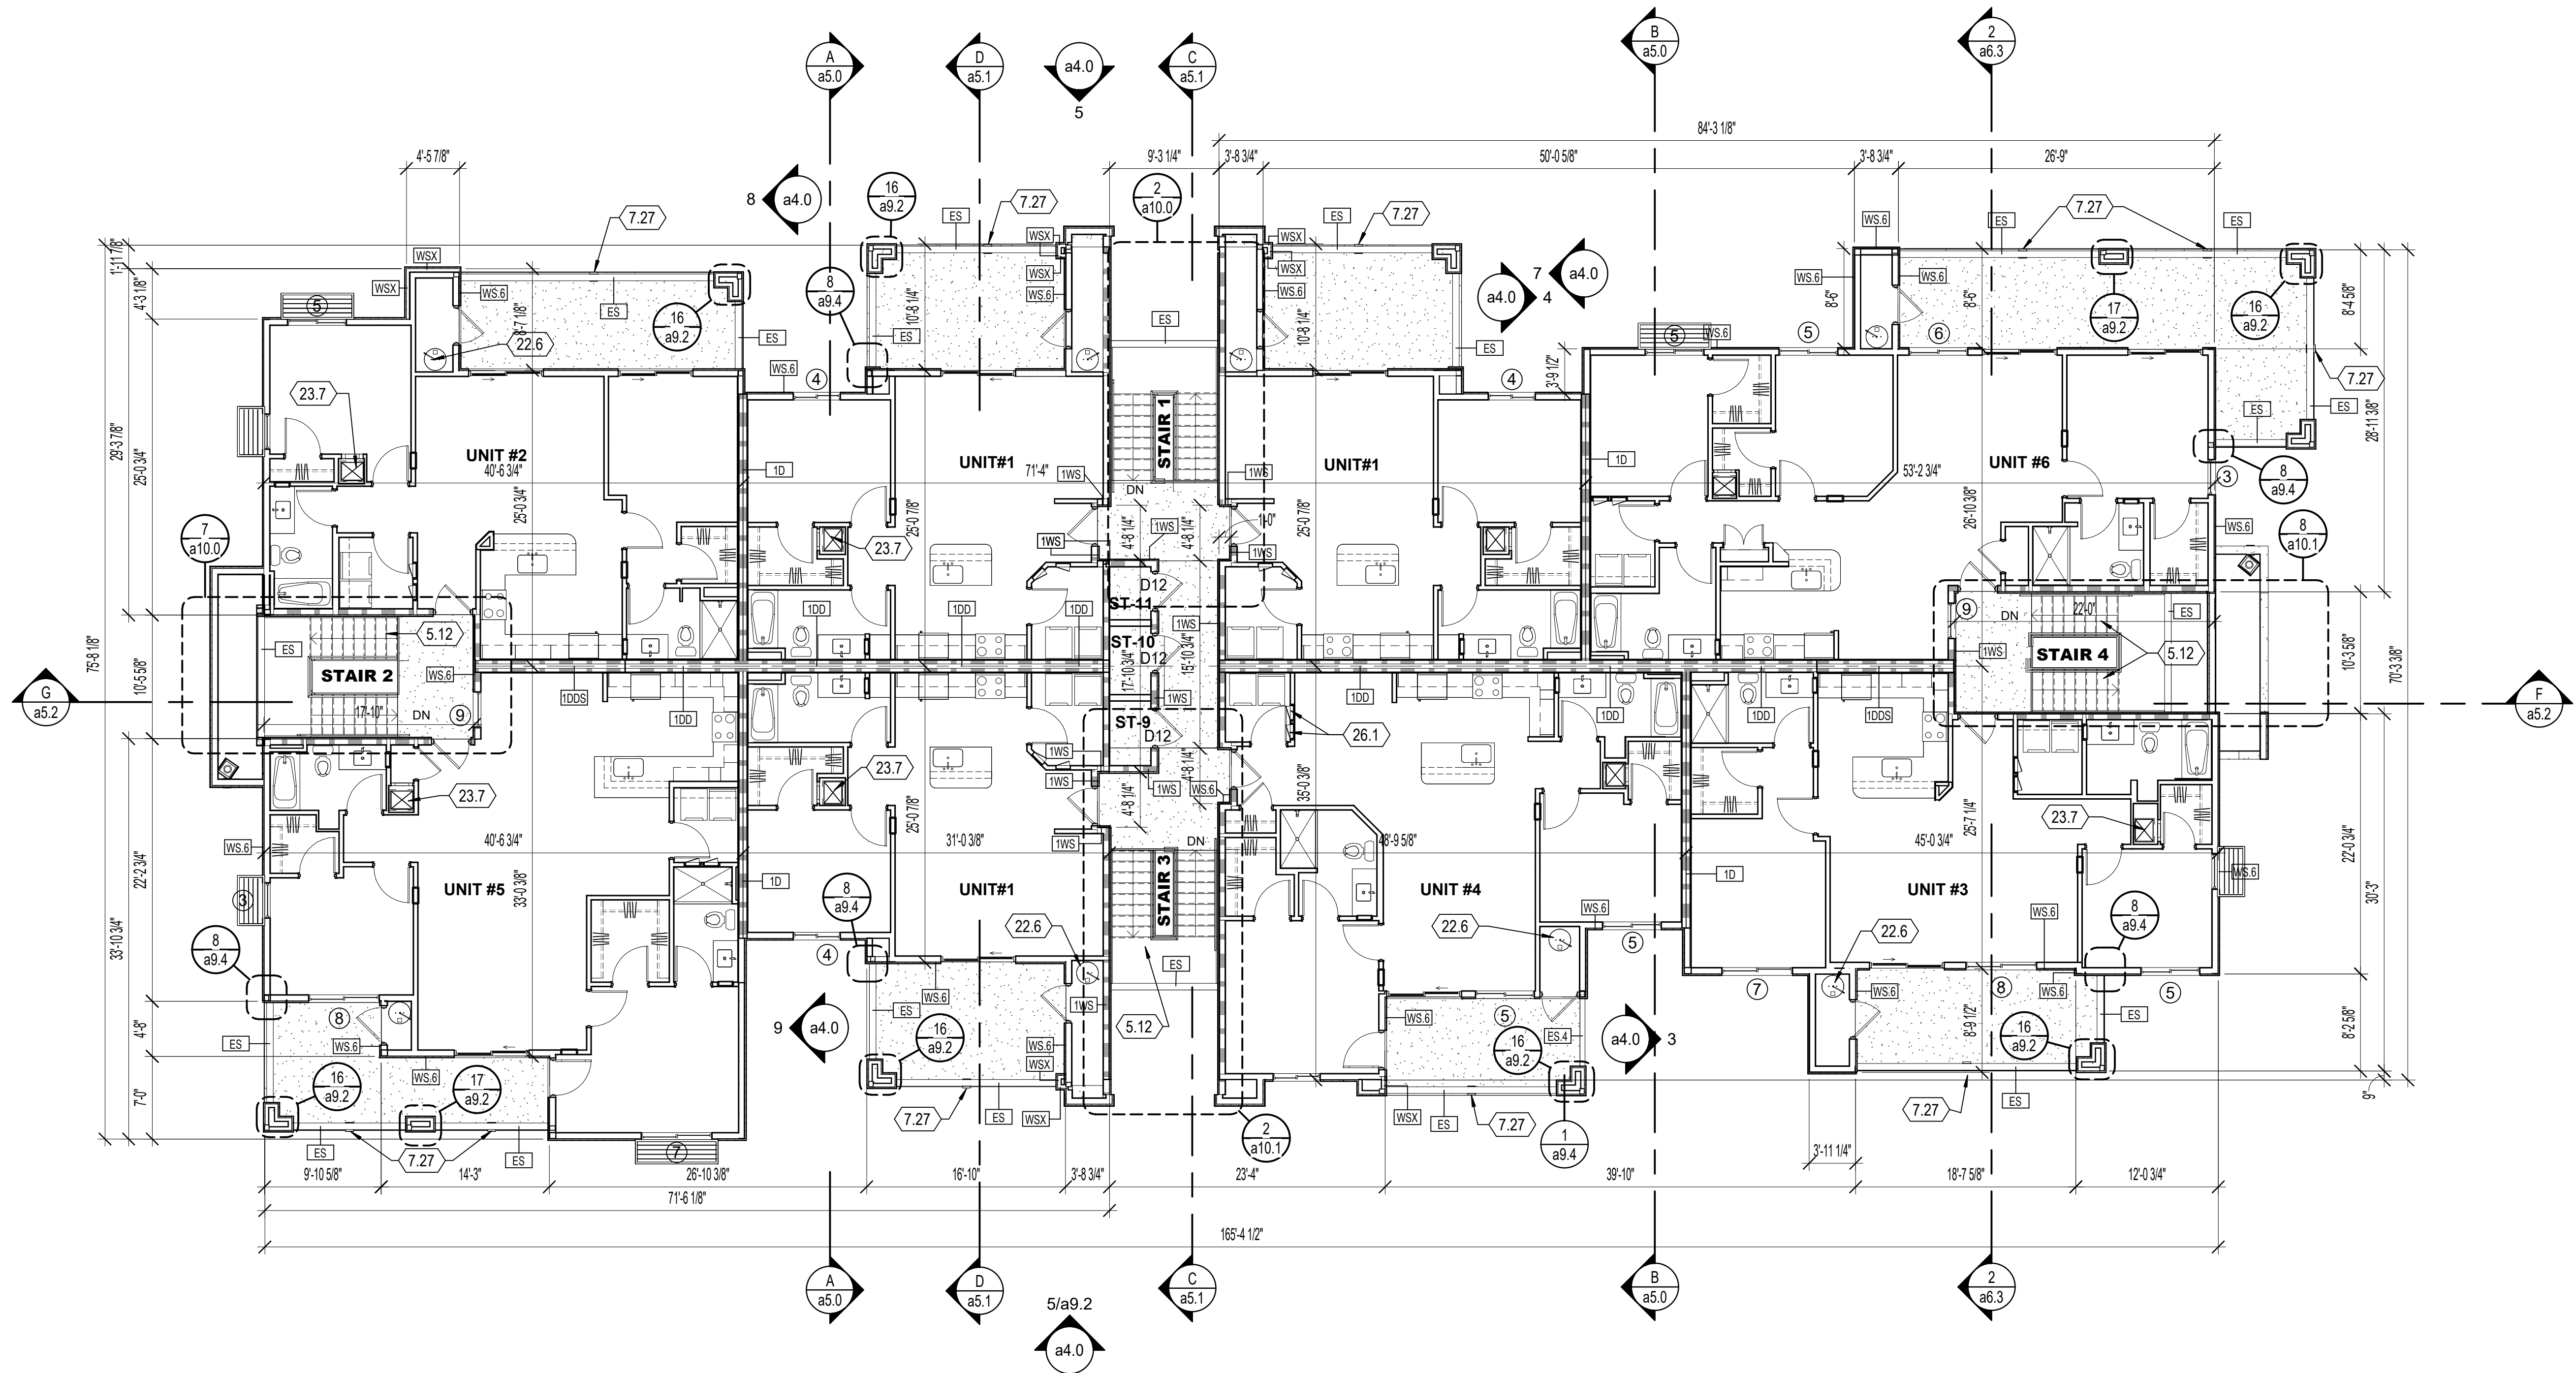

1
a1.1 floor plan - level 3 - building B
1/8" = 1'-0"

floor plan general notes

- DO NOT SCALE DRAWINGS. COORDINATE ALL WORK BETWEEN ARCHITECTURAL, STRUCTURAL, CIVIL, MECHANICAL, PLUMBING, COMMUNICATIONS AND ELECTRICAL DRAWINGS. CONFLICTS SHALL BE BROUGHT TO THE ATTENTION OF THE ARCHITECT PRIOR TO THE IMPLEMENTATION OF WORK.
- REFER TO PLUMBING, MECHANICAL AND ELECTRICAL DRAWINGS FOR ALL APPLICABLE CODES FOR REQUIRED CLEARANCES OF EQUIPMENT.
- SEE SHEET a8.0 FOR WINDOW AND DOOR TYPES.
- SEE SHEET a9.0 FOR WALL TYPES.
- SEE DOOR SCHEDULE ON SHEET a8.1 FOR DOOR RATINGS.
- DIMENSIONS THIS SHEET ARE TO FACE OF SHEATHING WHICH MATCHES SLAB EDGE, AND TO CENTER LINE OF DEMISING WALL.
- REFER TO SHEET g1.2 FOR MOUNTING HEIGHTS, CLEARANCES, CABINET AND COUNTER REQUIREMENTS.
- REFER TO SHEET g3.0 FOR RATED CEILING/FLOOR ASSEMBLY OPTIONS. AND g3.1 FOR RATED WALL ASSEMBLY DETAILS

keynotes


- 5.12 PRE-ENGINEERED STEEL STAIR SYSTEM WITH CONCRETE TREADS AND STEEL GUARDRAILS AND HANDRAILS.
- 7.27 SCUPPER THROUGH PATIO WALL, 4" X 8".
- 22.6 WATER HEATER, REFER TO PLUMBING.
- 23.7 HVAC UNIT - REFER TO MECHANICAL.
- 26.1 ELECTRICAL PANEL, REFER TO ELECTRICAL.

floor plan sheet legend

CLASS	ROOM NAME / NUMBER	
129		
A129B	DOOR NUMBER	SEE SHEET SERIES a8.1
A	WINDOW MARK	SEE SHEET SERIES a8.1
3	PARTITION TYPE	SEE SHEET SERIES a9.0

WALL SCHEDULE

MARK	DESCRIPTION	WIDTH	STC RATING	FIRE RATING	UL#
1D	5/8" TYPE 'X' GWB, 1/2" RESILIENT CHANNEL, 2x4 WOOD STUDS, 1/2" AIR SPACE, 2x4 WOOD STUDS, 1/2" SOUND BOARD, 1/2" SHEAR PANEL, 5/8" TYPE 'X' GWB	8 7/8"	40	1HR	U340
1DD	5/8" TYPE 'X' GWB, 5/8" RESILIENT CHANNEL, 2x4 WOOD STUDS, 4 1/2" AIR SPACE, 2x4 WOOD STUDS, 5/8" SOUND BOARD, 5/8" TYPE 'X' GWB	1'-0 1/2"	40	1HR	U386
1DDS	5/8" TYPE 'X' GWB, 5/8" RESILIENT CHANNEL, 2x4 WOOD STUDS, 4 1/2" AIR SPACE, 2x4 WOOD STUDS, 5/8" SOUND BOARD, 5/8" TYPE 'X' GWB	1'-0 7/8"	40	1HR	U386
1DS	5/8" TYPE 'X' GWB, 1/2" RESILIENT CHANNEL, 2x4 WOOD STUDS, 1/2" AIR SPACE, 2x4 WOOD STUDS, 1/2" SOUND BOARD, 1/2" SHEAR PANEL, 5/8" TYPE 'X' GWB	8 7/8"	40	1HR	U340
1W.6	5/8" GWB, 2x6 WOOD STUD, 5/8" GWB	6 3/4"	N/A	1HR	U305
1WS	5/8" GYP BD, 2x6 WD FRAMING, BATT INSULATION, 3/8"-1/2" WOOD SHEATHING, WEATHER BARRIER, 1" RIGID INSULATION, STUCCO SYSTEM	7 7/8"		1HR	EER #382
ES	STUCCO SYSTEM, WEATHER BARRIER, 3/8" WOOD SHEATHING, 2x6 WD FRAMING, 3/8" WOOD SHEATHING, WEATHER BARRIER, STUCCO SYSTEM	6 3/4"	N/A	NR	N/A
ES.4	STUCCO SYSTEM, WEATHER BARRIER, 3/8" WOOD SHEATHING, 2x4 WD FRAMING, 3/8" WOOD SHEATHING, WEATHER BARRIER, STUCCO SYSTEM	5"	N/A	NR	N/A
ESW	STUCCO SYSTEM, 1" RIGID FOAM, WOOD SHEATHING, 2x6 WOOD STUD, 3/8" SHEATHING AT PARAPETS	8 3/8"	N/A	NR	N/A
W	5/8" GWB, 2x4 WOOD STUD, 5/8" GWB	4 3/4"	N/A	NR	N/A
W2	5/8" GWB, 2x4 WOOD STUD, SOUND BATTS, 5/8" GWB	4 3/4"	-	NR	N/A
W2	5/8" GWB, 2x4 WOOD STUD, 5/8" GWB	2 3/4"	N/A	NR	N/A
W.6	5/8" GWB, 2x6 WOOD STUD, 5/8" GWB	6 3/4"	N/A	NR	N/A
WBX.6	BRICK VENEER ON SCRATCH COAT, 1" RIGID FOAM, WOOD SHEATHING, 2x6 WOOD STUD, 5/8" GYP SUM BOARD INTERIOR SIDE	8 1/2"	N/A	NR	N/A
WS.6	5/8" GYP BD, 2x6 WD FRAMING, INSULATION, 3/8"-1/2" WOOD SHEATHING, WEATHER BARRIER, 1" RIGID INSULATION, STUCCO SYSTEM	7 7/8"	N/A	NR	N/A
WSX	STUCCO SYSTEM, WEATHER BARRIER, 1" RIGID INSULATION, 3/8" WOOD SHEATHING, 2x4 WOOD FRAMING	5 1/4"	N/A	NR	N/A
WX.6	5/8" GWB, 2x6 WOOD STUD	6 1/8"	N/A	NR	N/A

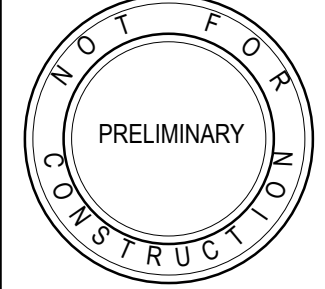

job
2415


date
03.06.25

revisions

HSL ENCANTADA O.V. MARKETPLACE
LUXURY APARTMENT HOMES
BUILDING TYPE B
ORO VALLEY, ARIZONA


floor plan level 3 - Building B

a1.1

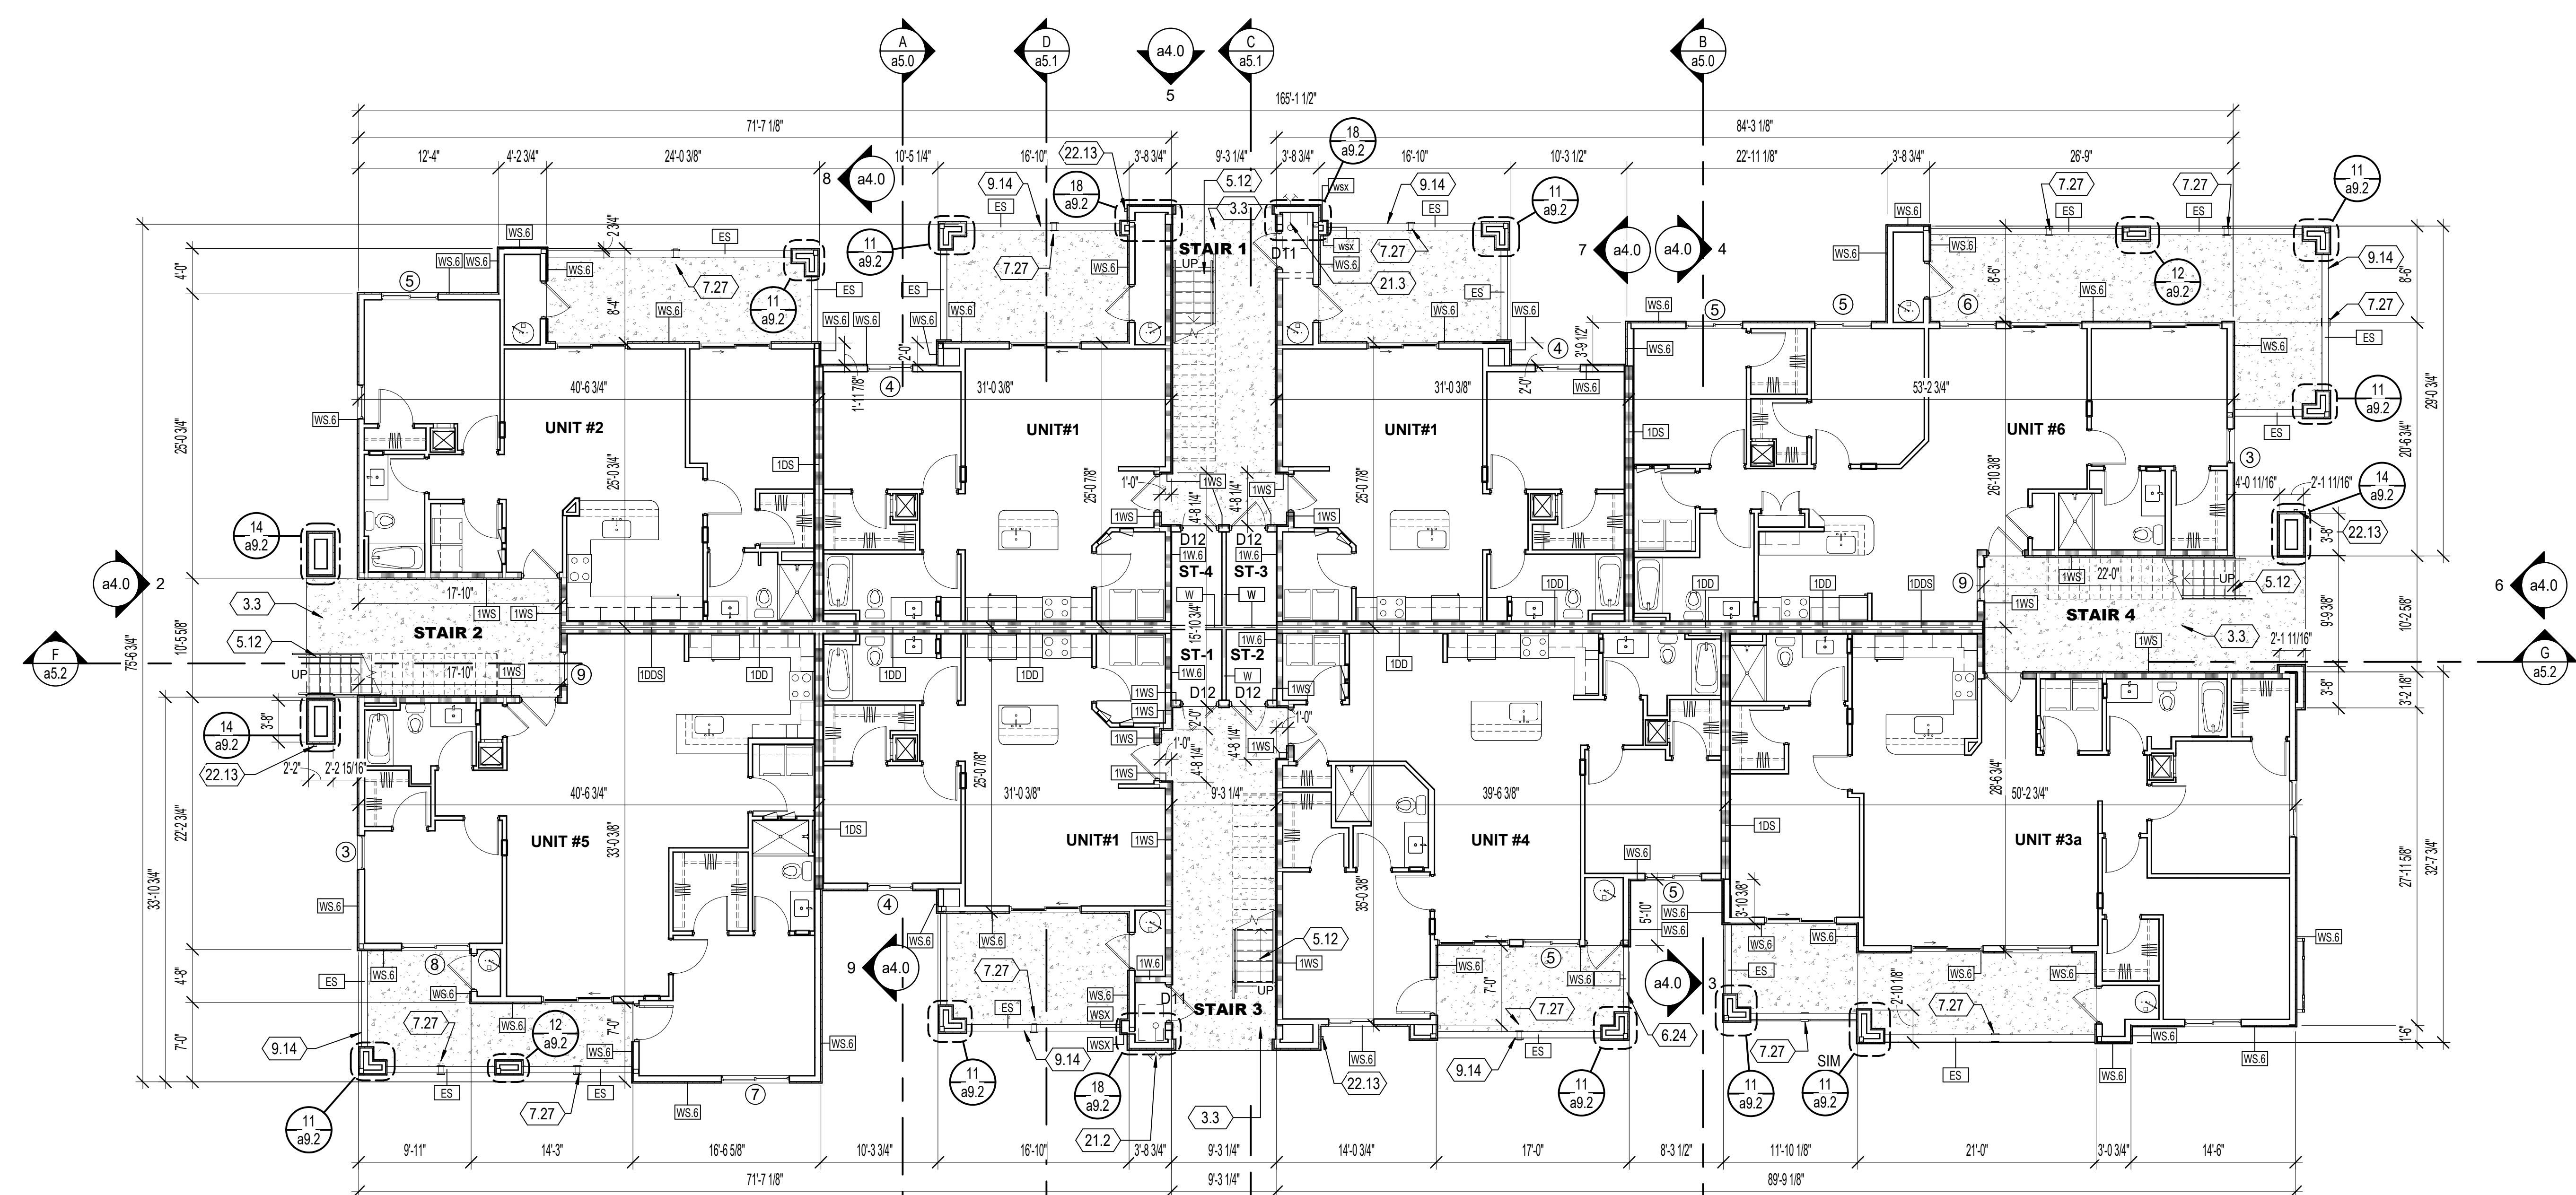

floor plan - level 1 - building A

1/8" = 1'-0"

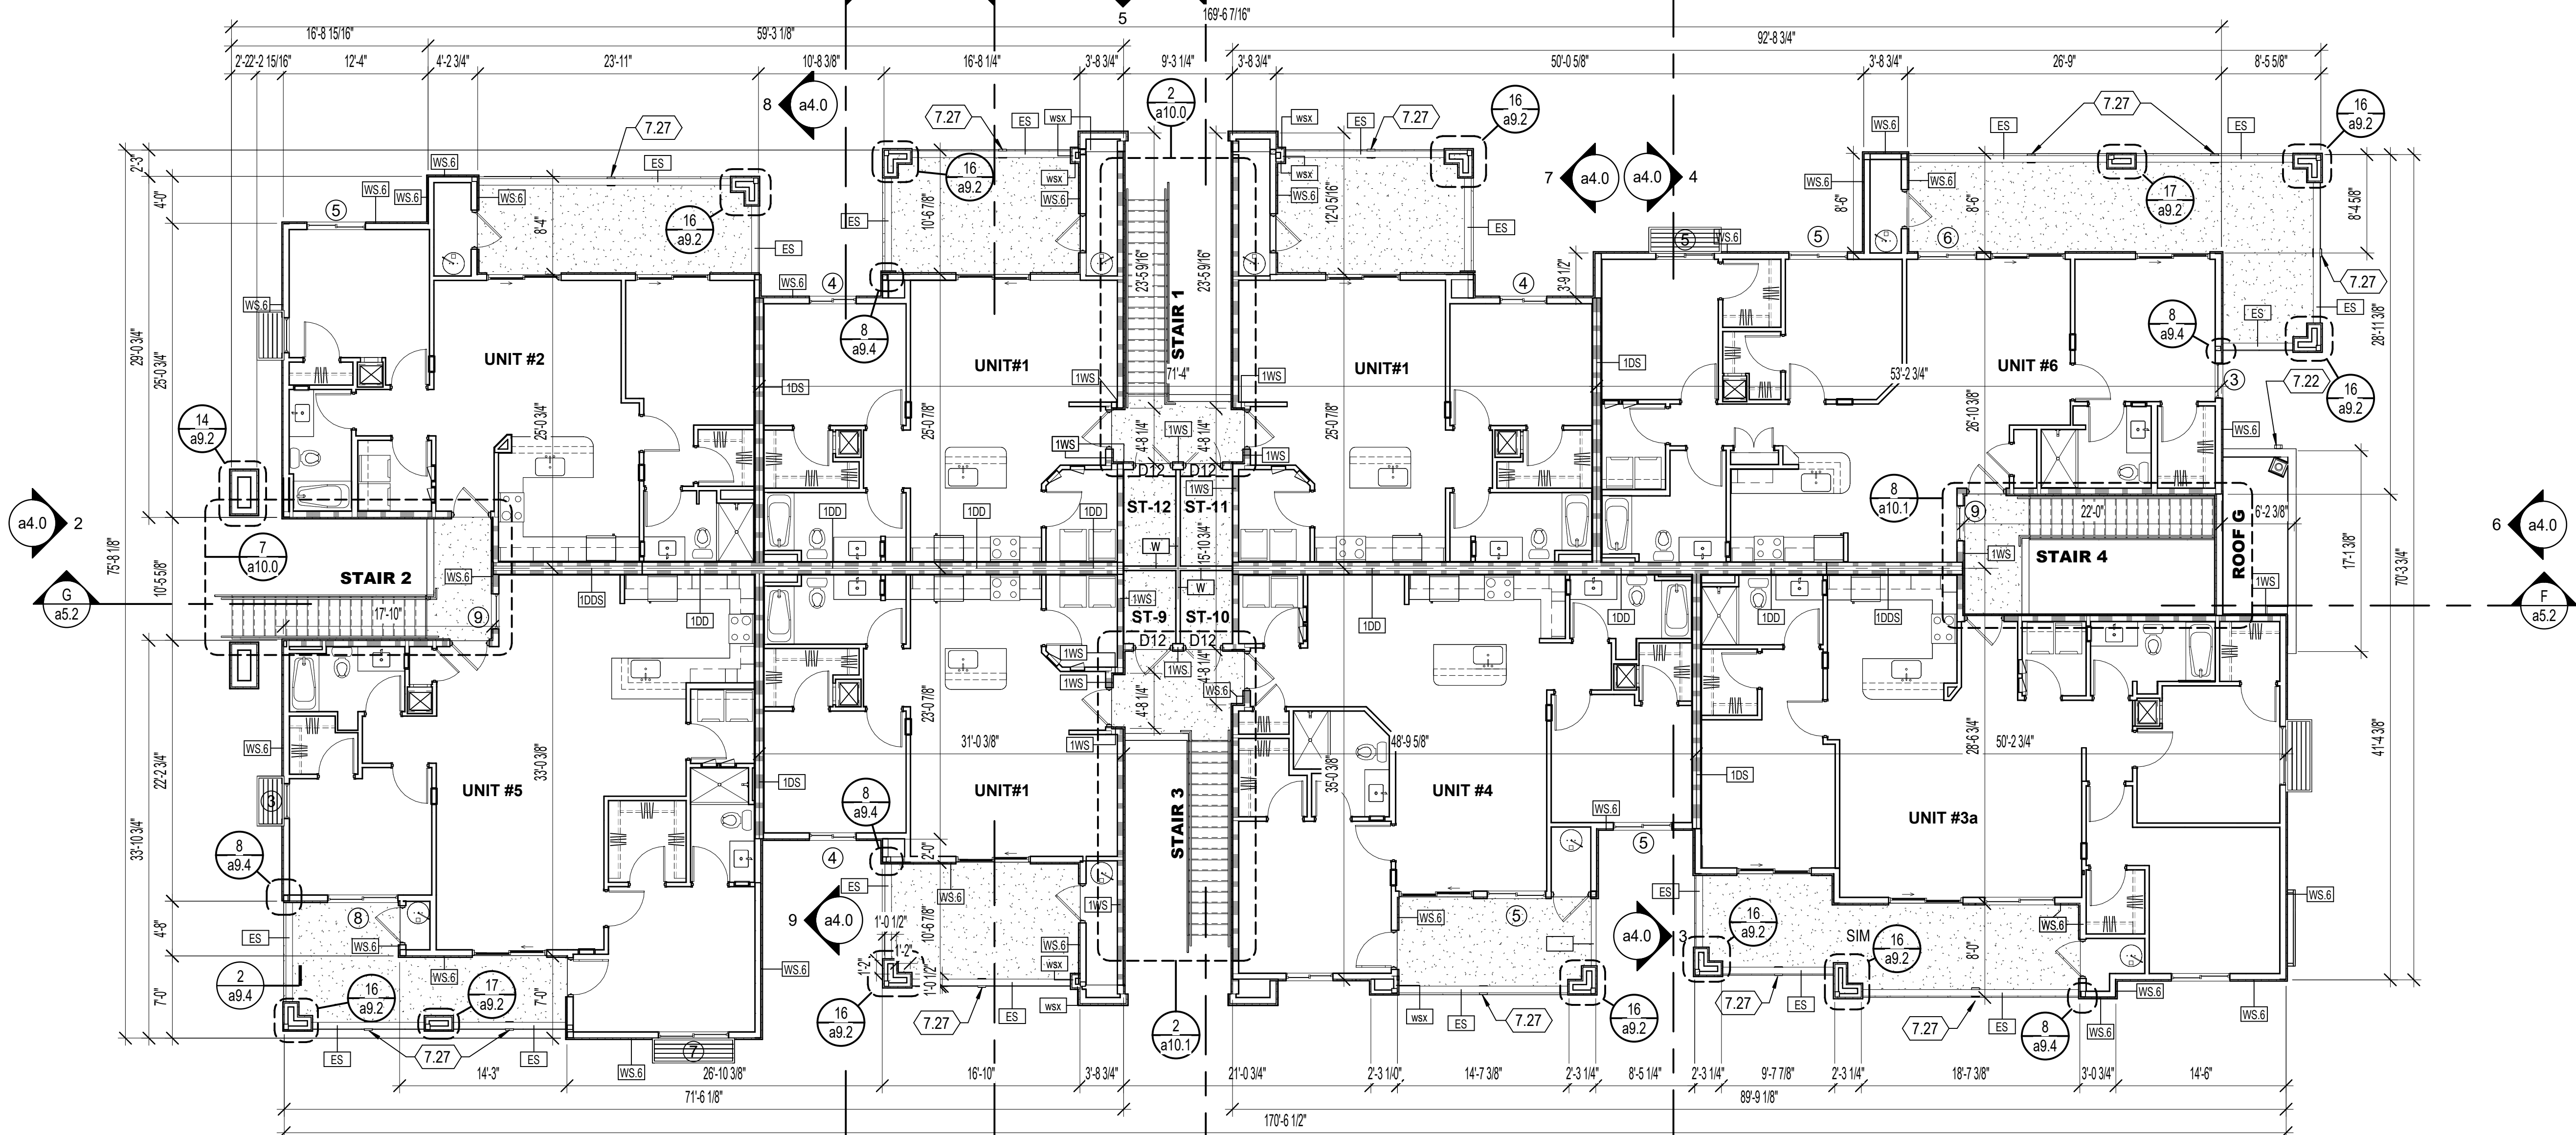

floor plan - level 2 - building A

1/8" = 1'-0"

floor plan general notes

- DO NOT SCALE DRAWINGS. COORDINATE ALL WORK BETWEEN ARCHITECTURAL, STRUCTURAL, CIVIL, MECHANICAL, PLUMBING, COMMUNICATIONS AND ELECTRICAL DRAWINGS. CONFLICTS SHALL BE BROUGHT TO THE ATTENTION OF THE ARCHITECT PRIOR TO THE IMPLEMENTATION OF WORK.
- REFER TO PLUMBING, MECHANICAL AND ELECTRICAL DRAWINGS FOR ALL APPLICABLE CODES FOR REQUIRED CLEARANCES OF EQUIPMENT.
- SEE SHEET a8.0 FOR WINDOW AND DOOR TYPES.
- SEE SHEET a9.0 FOR WALL TYPES.
- SEE DOOR SCHEDULE ON SHEET a8.1 FOR DOOR RATINGS.
- DIMENSIONS THIS SHEET ARE TO FACE OF SHEATHING WHICH MATCHES SLAB EDGE, AND TO CENTER LINE OF DEMISING WALL.
- REFER TO SHEET g3.2 FOR MOUNTING HEIGHTS, CLEARANCES, CABINET AND COUNTER REQUIREMENTS.
- REFER TO SHEET g3.0 FOR RATED CEILING/FLOOR ASSEMBLY OPTIONS, AND g3.1 FOR RATED WALL ASSEMBLY DETAILS

keynotes


- 3.3 CONCRETE SIDEWALK, REFER TO LANDSCAPE AND CIVIL.
- 5.12 PRE-ENGINEERED STEEL STAIR SYSTEM WITH CONCRETE TREADS AND STEEL GUARDRAILS AND HANDRAILS.
- 6.24 2X4 FRAMING THIS SECTION OF WALL FOR DOOR CLEARANCE.
- 7.22 OVERFLOW DRAIN SCUPPER THROUGH WALL. 2" ABOVE LEVEL OF ADJACENT ROOF DRAIN. SEE DETAIL 14 SHEET A9.5.
- 7.27 SCUPPER THROUGH PATIO WALL, 4" X 8".
- 9.14 STUCCO SYSTEM OVER WOOD FRAMED PARTIAL HEIGHT WALL.
- 21.2 FIRE DEPARTMENT CONNECTION.
- 21.3 ALTERNATE FIRE RISER LOCATION - REFER TO CIVIL SITE PLAN FOR CONNECTION LOCATION.
- 22.13 RAIN WATER LEADER OUTLET.

floor plan sheet legend

CLASS	ROOM NAME / NUMBER	
129		
A129B	DOOR NUMBER	SEE SHEET SERIES a8.1
A	WINDOW MARK	SEE SHEET SERIES a8.1
3	PARTITION TYPE	SEE SHEET SERIES a9.0

WALL SCHEDULE

MARK	DESCRIPTION	WIDTH	STC RATING	FIRE RATING	UL#
1DD	5/8" TYPE 'X' GWB, 5/8" RESILIENT CHANNEL, 2x4 WOOD STUDS, 4 1/2" AIR SPACE, 2x4 WOOD STUDS, 5/8" SOUND BOARD, 5/8" TYPE 'X' GWB	1'-0 1/2"	40	1HR	U386
1DDs	5/8" TYPE 'X' GWB, 5/8" RESILIENT CHANNEL, 2x4 WOOD STUDS, 4 1/2" AIR SPACE, 2x4 WOOD STUDS, 5/8" SOUND BOARD, 5/8" TYPE 'X' GWB	1'-0 7/8"	40	1HR	U386
1DS	5/8" TYPE 'X' GWB, 1/2" RESILIENT CHANNEL, 2x4 WOOD STUDS, 1/2" AIR SPACE, 2x4 WOOD STUDS, 1/2" SOUND BOARD, 1/2" SHEAR PANEL, 5/8" TYPE 'X' GWB	8 7/8"	40	1HR	U340
1W.6	5/8" GWB, 2x6 WOOD STUD, 5/8" GWB	6 3/4"	N/A	1HR	U305
1WS	5/8" GYP BD, 2x6 WD FRAMING, BATT INSULATION, 3/8"-1/2" WOOD SHEATHING, WEATHER BARRIER, 1" RIGID INSULATION, STUCCO SYSTEM	7 7/8"	N/A	1HR	EER #362
ES	STUCCO SYSTEM, WEATHER BARRIER, 1" RIGID INSULATION, 3/8" WOOD SHEATHING, 2x6 WD FRAMING, 3/8" WOOD SHEATHING, WEATHER BARRIER, 1" RIGID INSULATION, STUCCO SYSTEM	6 3/4"	N/A	NR	N/A
W	5/8" GWB, 2x4 WOOD STUD, 5/8" GWB	4 3/4"	N/A	NR	N/A
W.2	5/8" GWB, 2x4 WOOD STUD, 5/8" GWB	2 3/4"	N/A	NR	N/A
W.6	5/8" GWB, 2x6 WOOD STUD, 5/8" GWB	6 3/4"	N/A	NR	N/A
WB.6	WESTERN ONE COAT STUCCO SYSTEM, 1" RIGID FOAM, WOOD SHEATHING, 2x6 WOOD STUD, 5/8" GYPSUM BOARD INTERIOR SIDE.	8 1/2"			-
WS.6	<varies>	<varies>			<varies>
wsx	STUCCO SYSTEM, WEATHER BARRIER, 1" RIGID INSULATION, 3/8" WOOD SHEATHING, 2x6 WD FRAMING	5 1/4"	N/A	NR	N/A

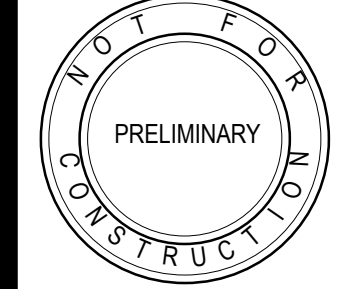

job
2415


date
03.06.25

revisions


HSL ENCANTADA MARKETPLACE
LUXURY APARTMENT HOMES
BUILDING TYPE A
ORO VALLEY, ARIZONA

floor plan level 1 and 2 - Building A


a1.0

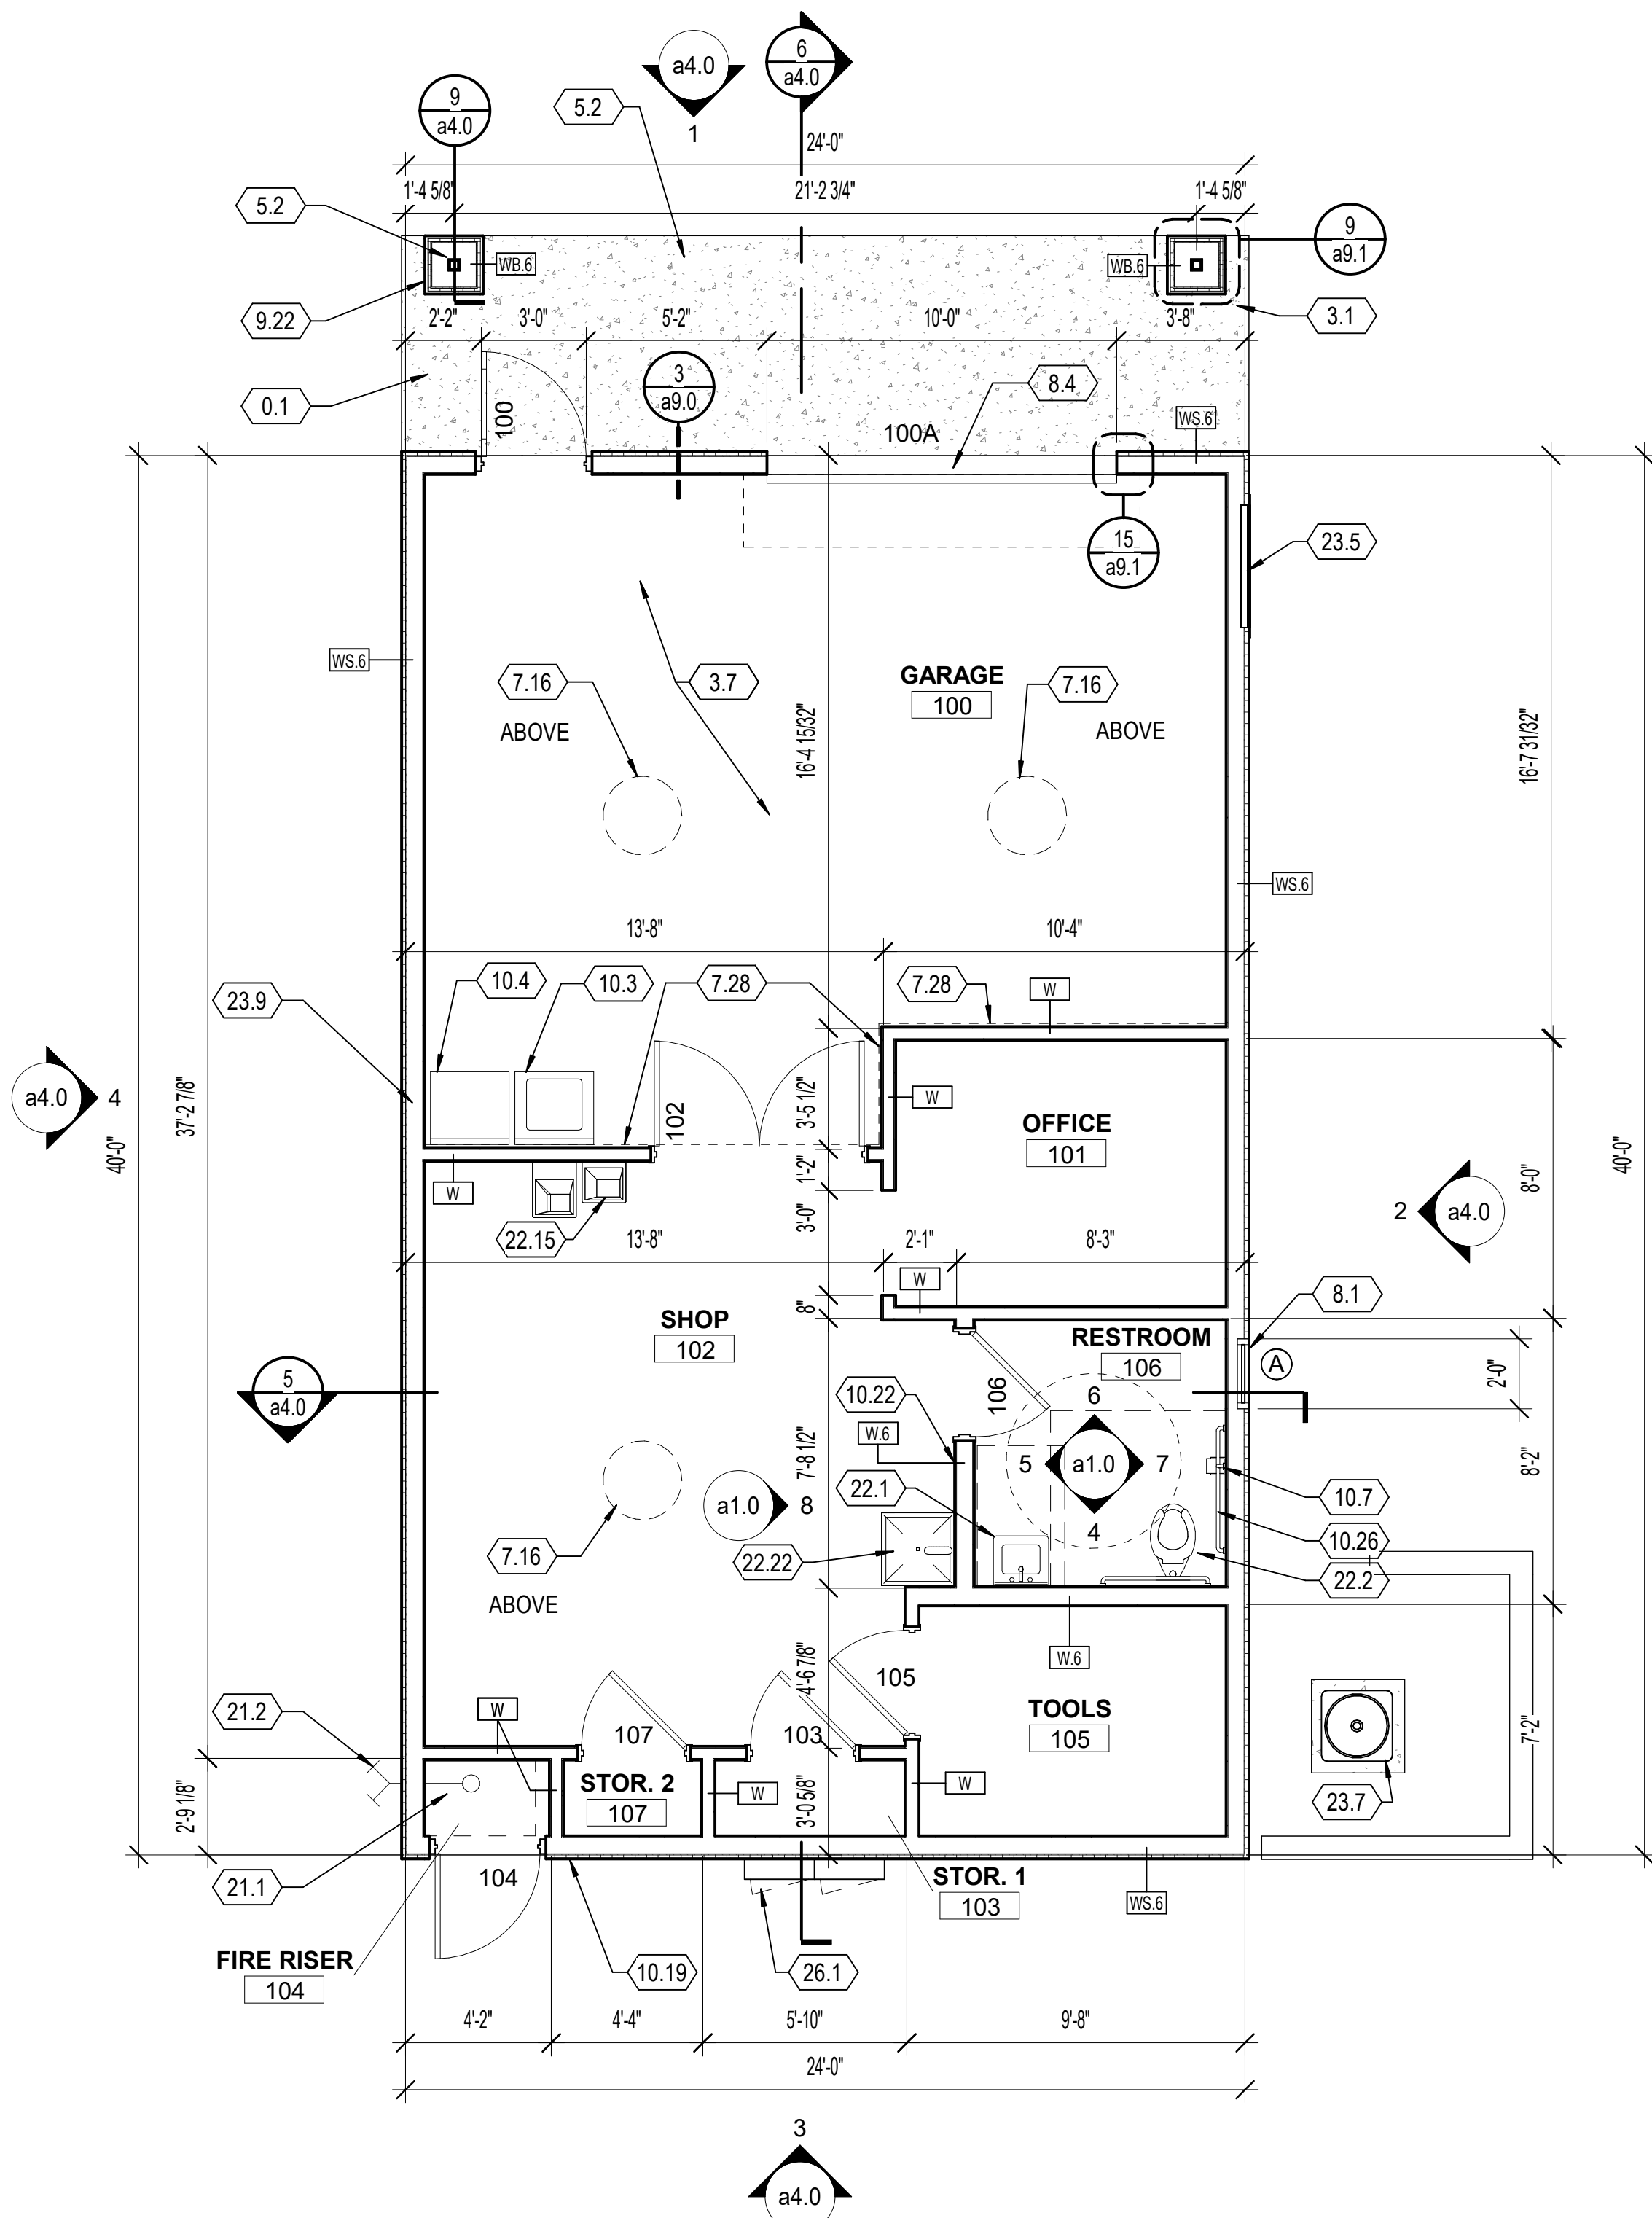


1 floor plan
1/4" = 1'-0"

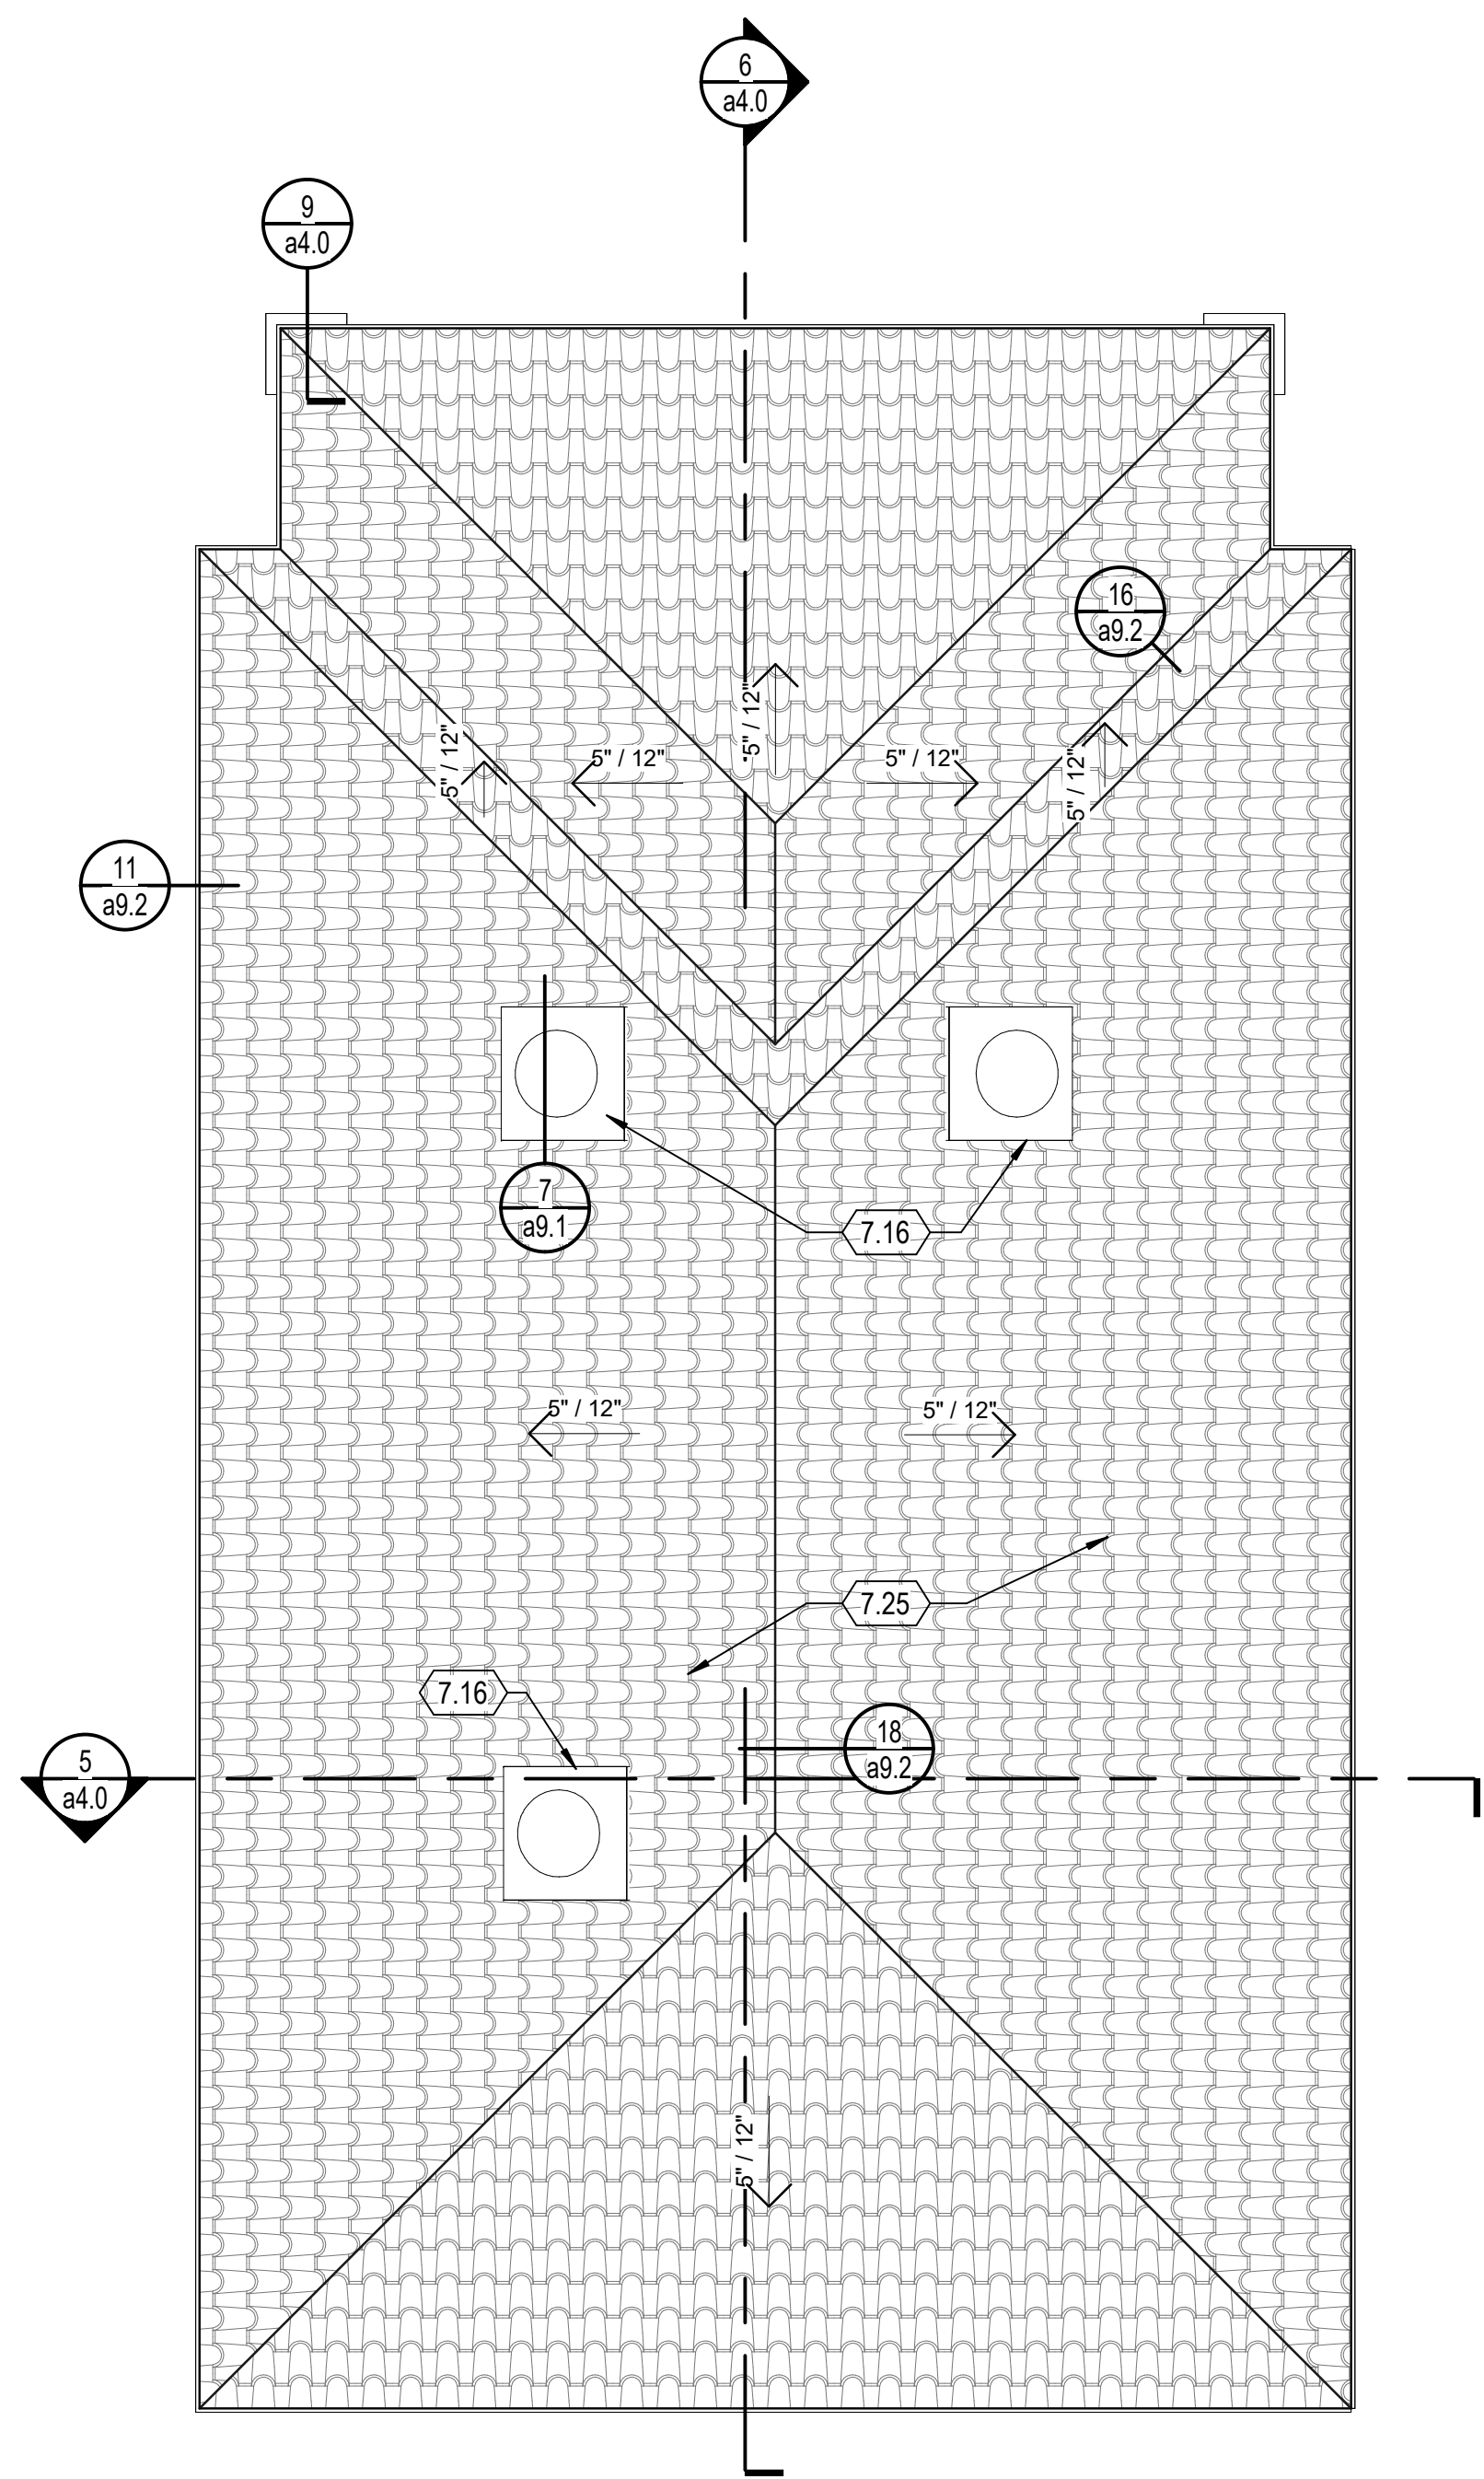


2 roof plan
1/4" = 1'-0"

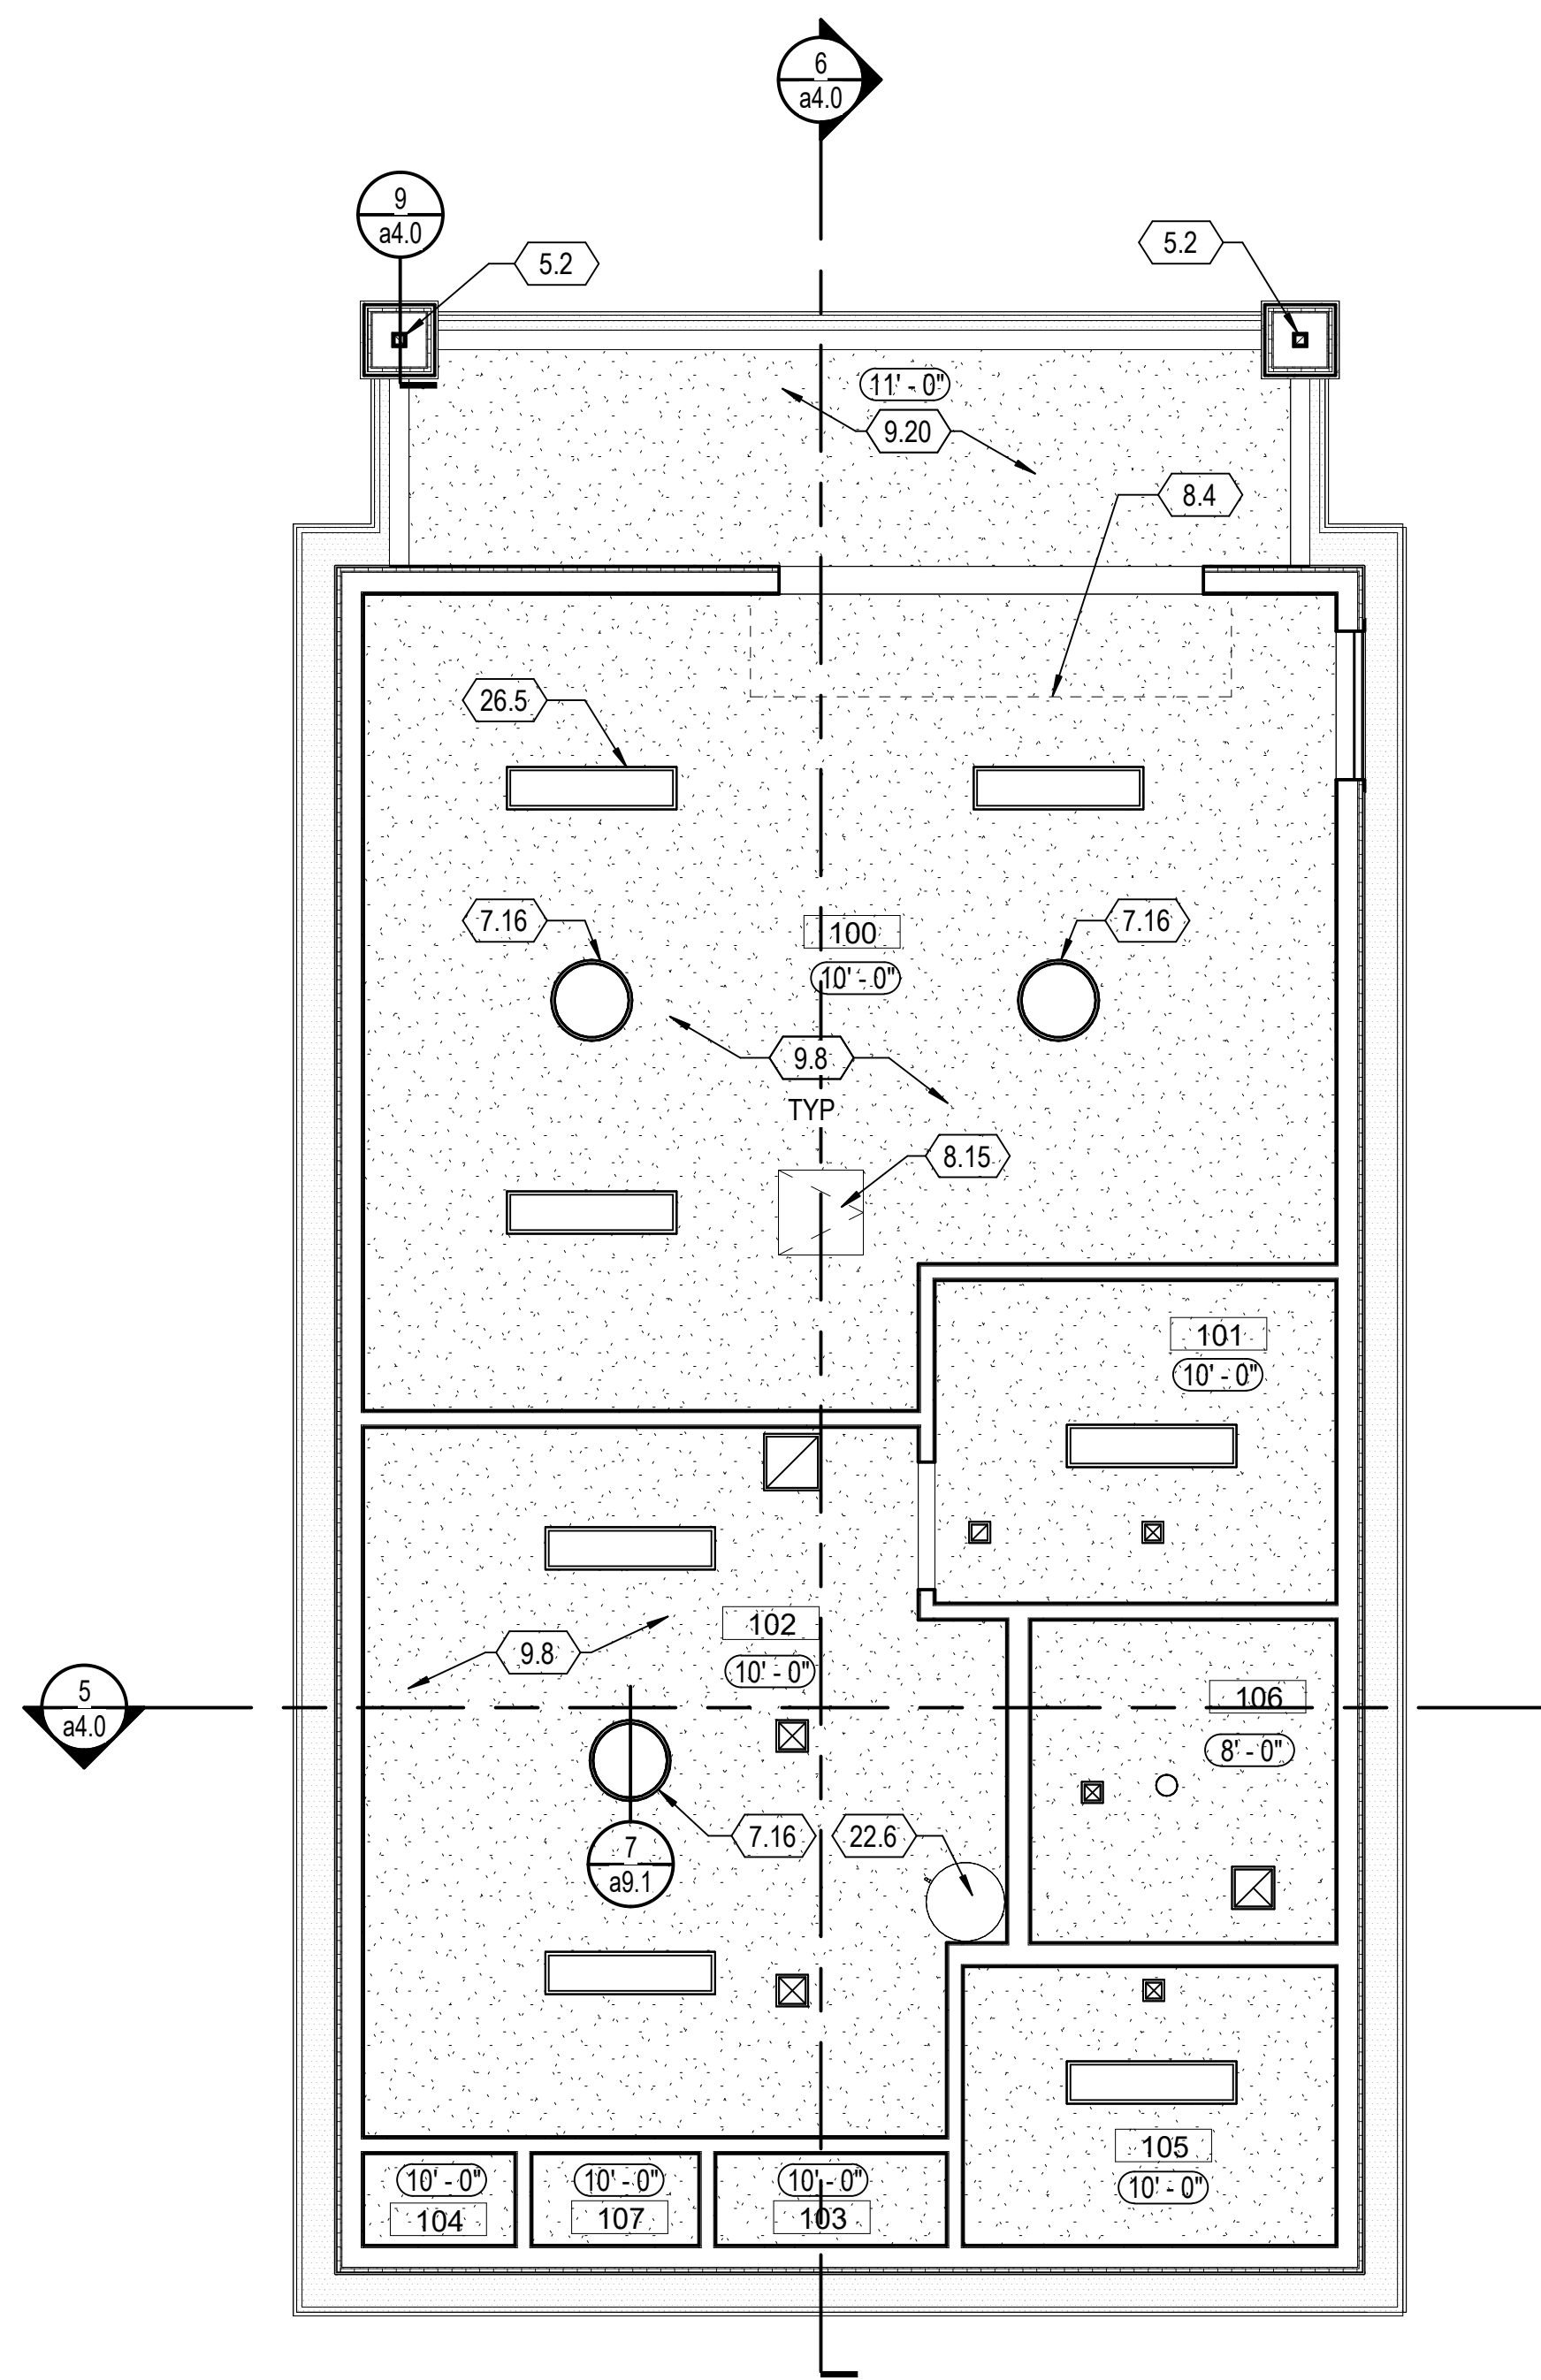


3 reflected ceiling plan
1/4" = 1'-0"

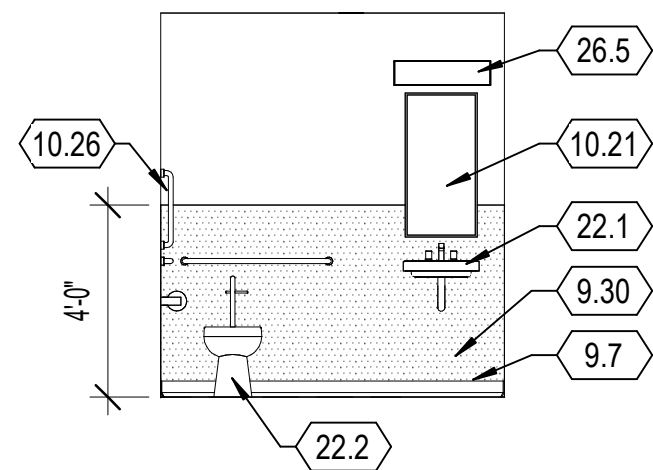


4 restroom 106 - s
1/4" = 1'-0"

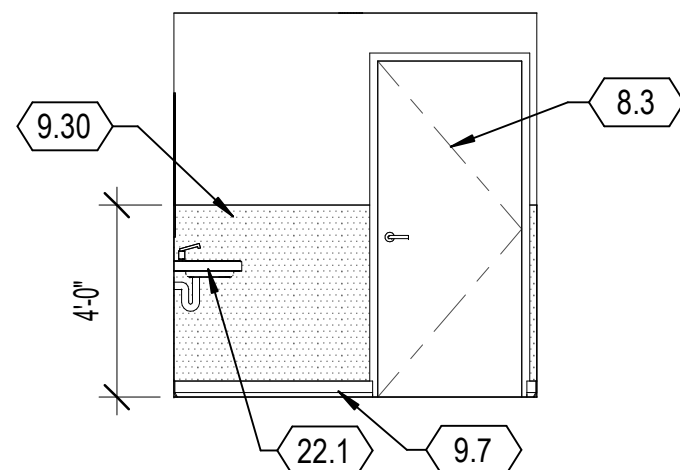


5 restroom 106 - w
1/4" = 1'-0"

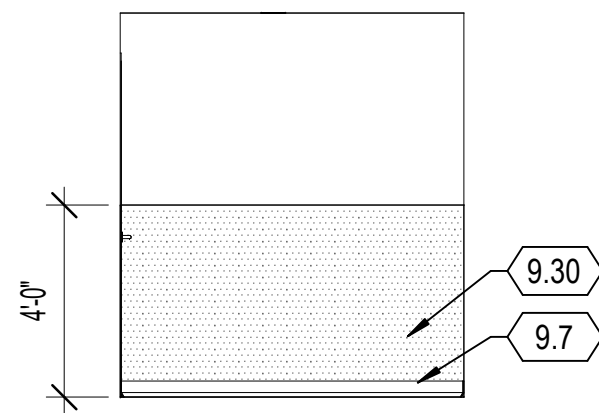

6 restroom 106 - n
1/4" = 1'-0"

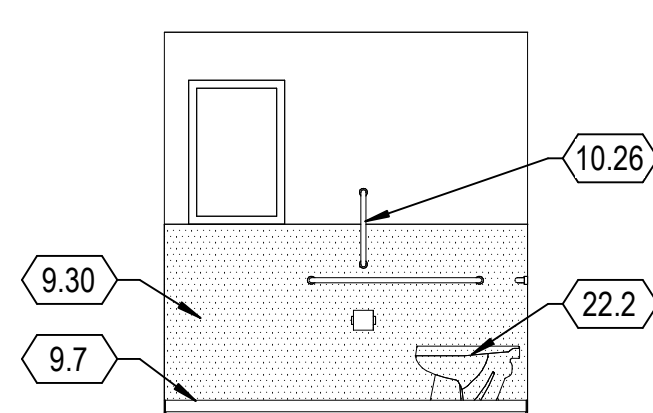

7 restroom 106 - e
1/4" = 1'-0"

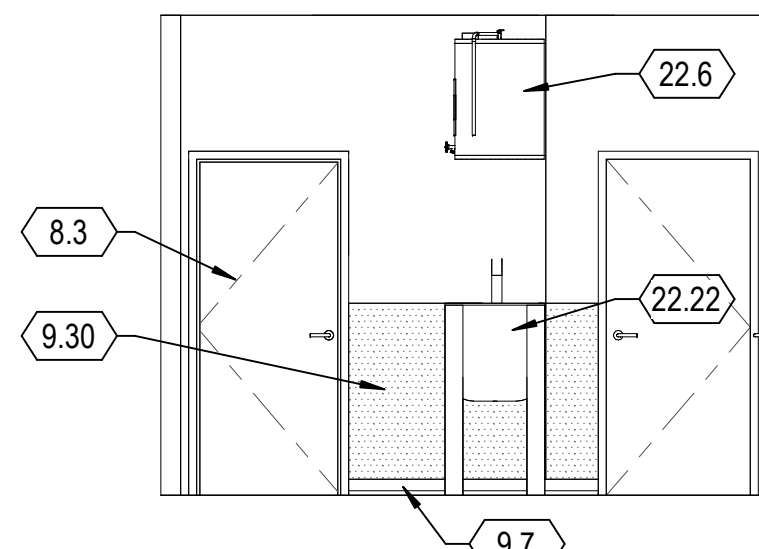


8 shop 102 - e
1/4" = 1'-0"

- general notes**
- DO NOT SCALE DRAWINGS. COORDINATE ALL WORK BETWEEN ARCHITECTURAL, STRUCTURAL, CIVIL, MECHANICAL, PLUMBING, COMMUNICATIONS AND ELECTRICAL DRAWINGS. CONFLICTS SHALL BE BROUGHT TO THE ATTENTION OF THE ARCHITECT PRIOR TO THE IMPLEMENTATION OF WORK.
 - REFER TO PLUMBING, MECHANICAL AND ELECTRICAL DRAWINGS FOR ALL APPLICABLE CODES FOR REQUIRED CLEARANCES OF EQUIPMENT.
 - SEE SHEET a8.0 FOR WINDOW AND DOOR TYPES.
 - SEE SHEET a9.0 FOR WALL TYPES.
 - SEE MECHANICAL, PLUMBING AND ELECTRICAL FOR ALL PENETRATIONS THROUGH ROOFS. REFER TO TYPICAL DETAILS.
 - ROOF HEIGHTS SHOWN ARE TOP ROOF UNO.
 - SEE SHEET a9.9 FOR TYPICAL ACCESSIBILITY DETAILS, CLEARANCES, MOUNTING HEIGHTS AND REQUIREMENTS.
 - UNVENTILATED ATTIC SPACES. ROOF INSULATION SHALL BE AIR-IMPERMEABLE SPRAY FOAM APPLIED TO THE BOTTOM OF THE ROOF DECK, CONTINUOUS.


- keynotes**
- 0.1 LINE OF ROOF ABOVE.
 - 3.1 CONCRETE FOOTING, REFER TO STRUCTURAL.
 - 3.7 CONCRETE SLAB ON STEEL DECK, REFER TO STRUCTURAL.
 - 5.2 STEEL COLUMN, REFER TO STRUCTURAL.
 - 7.16 DOMED ACRYLIC SKYLIGHT SYSTEM WITH 24" DIAMETER LENSE AT CEILING LEVEL.
 - 7.25 CONCRETE ROOF TILE SYSTEM OVER BATTENS.
 - 7.28 VAPOR BARRIER AT BACK OF GWB THIS SIDE OF WALL. CONTINUOUS AND SEALED FLOOR TO BOTTOM OF DECK.
 - 8.1 ALUMINUM FRAME WINDOW SYSTEM WITH INSULATED GLAZING.
 - 8.3 DOOR AND FRAME, REFER TO DOOR SCHEDULE.
 - 8.4 OVERHEAD COILING DOOR.
 - 8.15 24" X 30" CEILING ACCESS PANEL, COORDINATE FINAL LOCATION WITH OWNER.
 - 9.7 WALL BASE.
 - 9.8 GWB CEILING.
 - 9.20 GWB CEILING SUSPENDED ON LIGHT GAUGE METAL FRAMING.
 - 9.22 BRICK VENEER.
 - 9.30 FIBERGLASS REINFORCED PLASTIC WALL PANEL WAINSCOT.
 - 10.3 WASHER.
 - 10.4 DRYER.
 - 10.7 TOILET PAPER DISPENSER.
 - 10.19 FIRE DEPARTMENT KEY BOX, KNOX BOX OR EQUAL AS APPROVED BY AHJ.
 - 10.21 MIRROR.
 - 10.22 ADA COMPLIANT RESTROOM SIGNAGE. REFER TO DETAIL 14 SHEET G1.2.
 - 10.26 ACCESSIBLE GRAB BARS.
 - 21.1 FIRE RISER ASSEMBLY.
 - 22.1 FIRE DEPARTMENT CONNECTION.
 - 22.1 SINK, REFER TO PLUMBING.
 - 22.2 TOILET, REFER TO PLUMBING.
 - 22.6 WATER HEATER, REFER TO PLUMBING.
 - 22.15 DRINING FOUNTAIN - REFER TO PLUMBING.
 - 22.22 LAUNDRY SINK- REFER TO PLUMBING.
 - 23.5 HIGH/LOW RETURN REGISTERS IN WALL - REFER TO MECHANICAL.
 - 23.7 HVAC UNIT - REFER TO MECHANICAL.
 - 23.9 DRYER VENT THROUGH WALL - REFER TO MECHANICAL.
 - 26.1 ELECTRICAL PANEL, REFER TO ELECTRICAL.
 - 26.5 LIGHT FIXTURE, REFER TO ELECTRICAL.

floor plan sheet legend		
CLASS 129	ROOM NAME / NUMBER	SEE SHEET SERIES "X"
A129B	DOOR NUMBER	SEE SHEET SERIES "X"
(A)	WINDOW MARK	SEE SHEET SERIES "X"
3	PARTITION TYPE	SEE SHEET SERIES "X"


- general notes**
- 1' x 4' LIGHT FIXTURE
 - MECHANICAL SUPPLY REGISTER
 - MECHANICAL RETURN REGISTER
 - MECHANICAL EXHAUST REGISTER
 - GYPSUM WALLBOARD SOFFIT / CEILING
 - STUCCO SOFFIT / CEILING
 - 2' SKYLIGHT LENS
 - CAN LIGHT

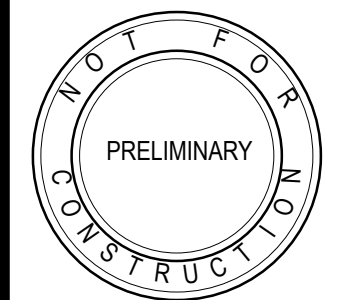

revisions

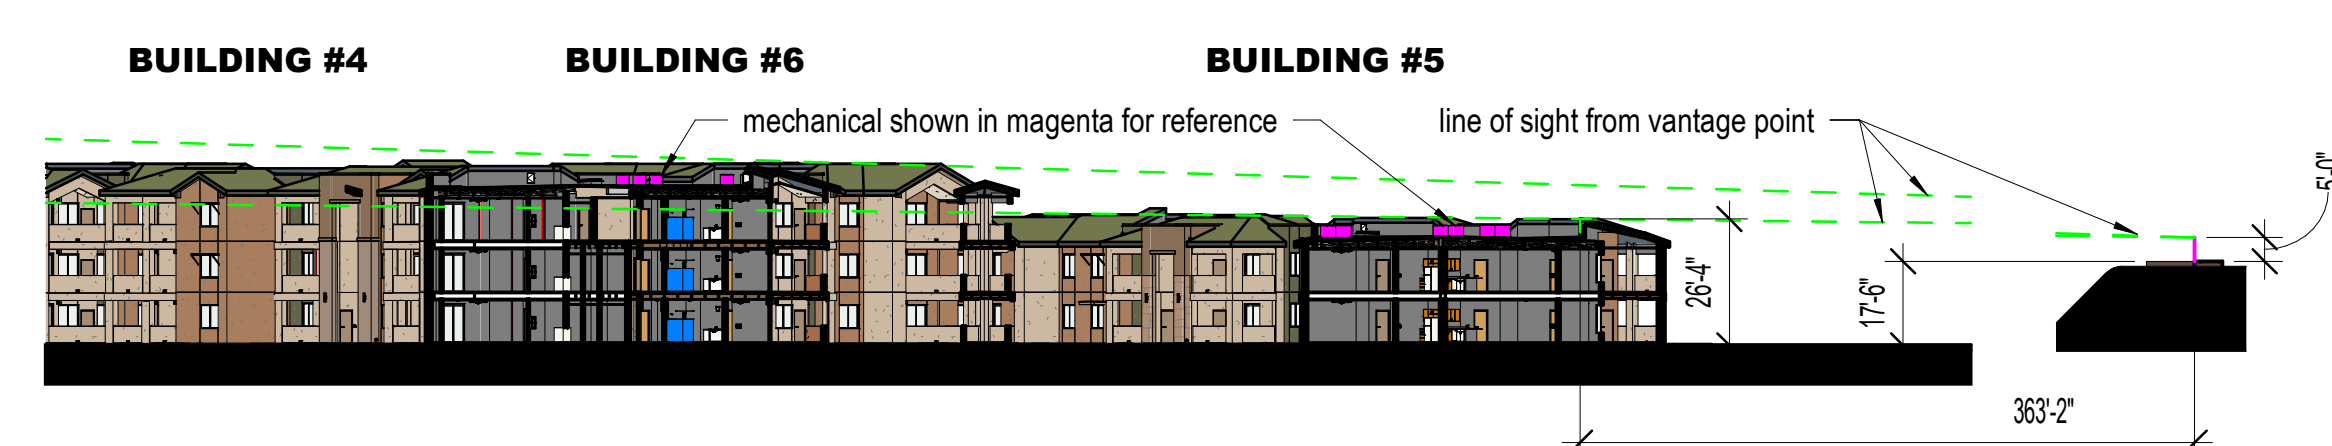

offsite view section 2 - intersection

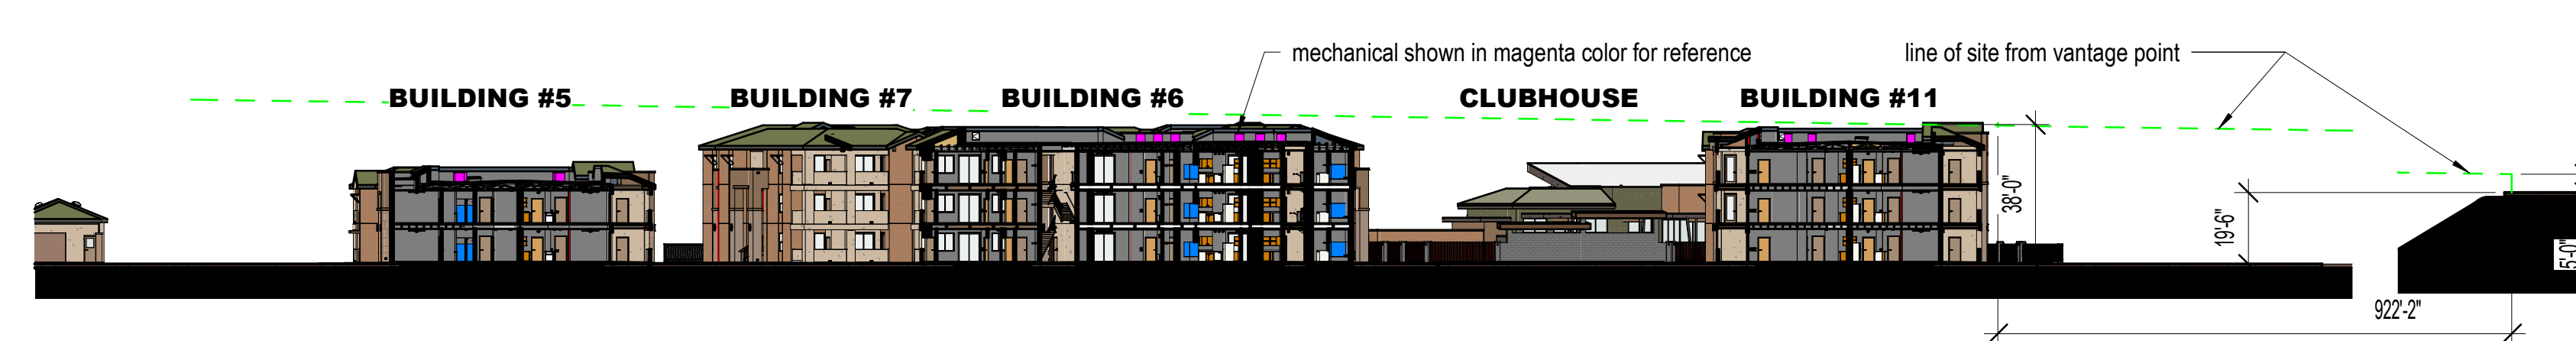

3 offsite view section 3 - catalina shadows
a5.0 1" = 40'-0"



offsite view section 1 - bridge