




NORTH ELEVATION

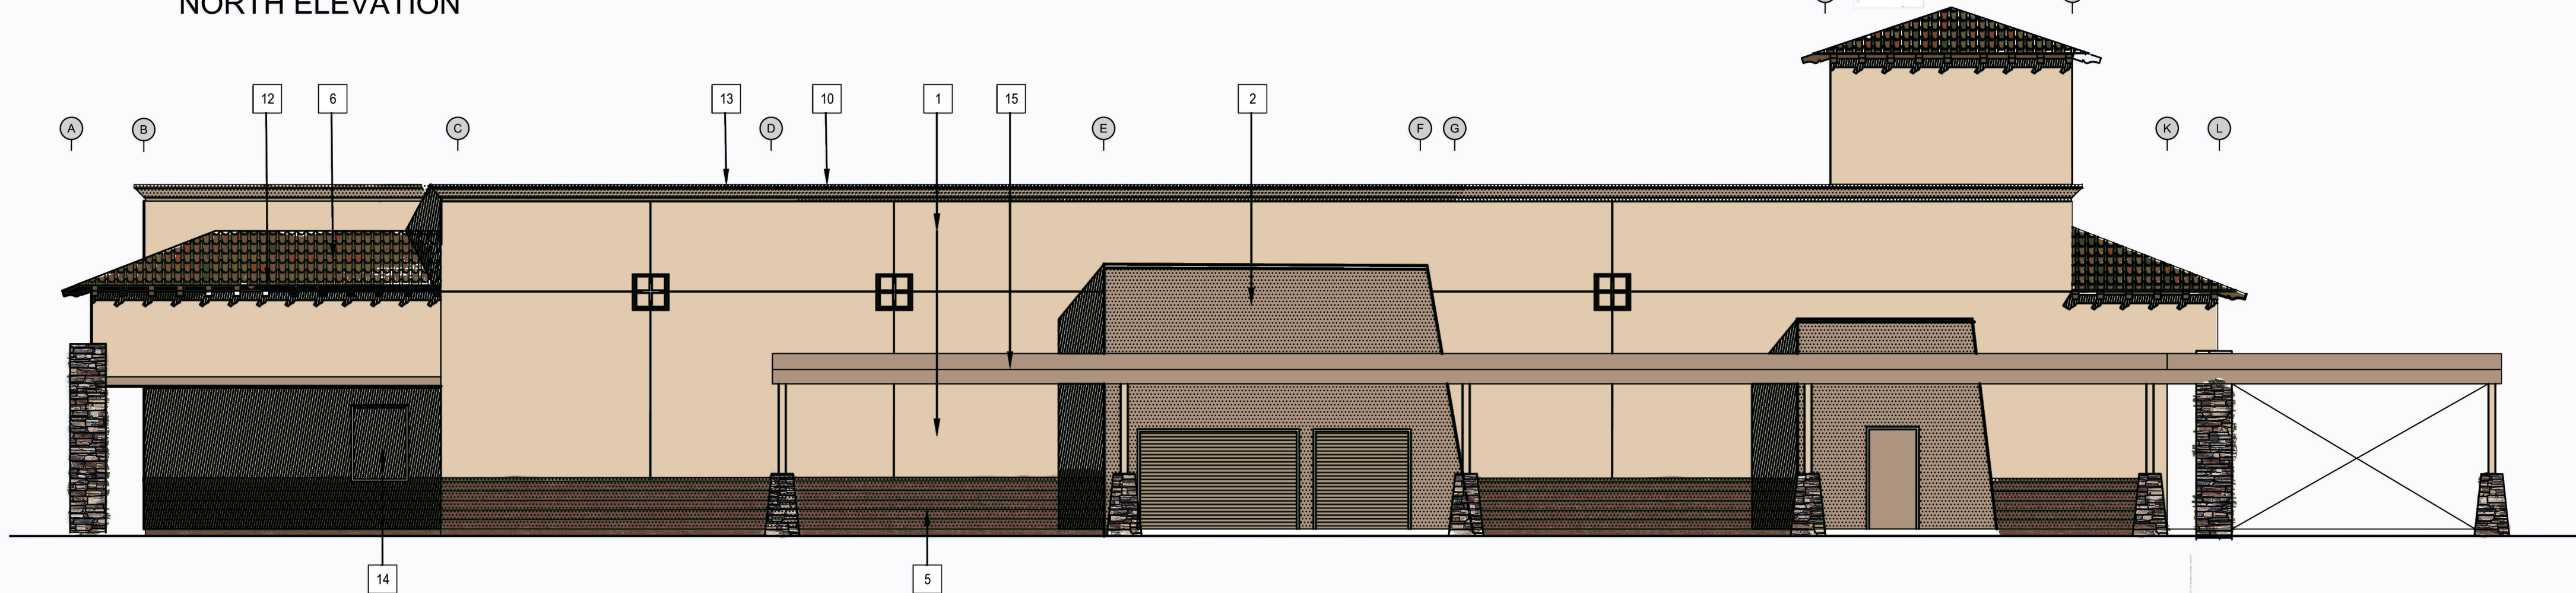

SOUTH ELEVATION

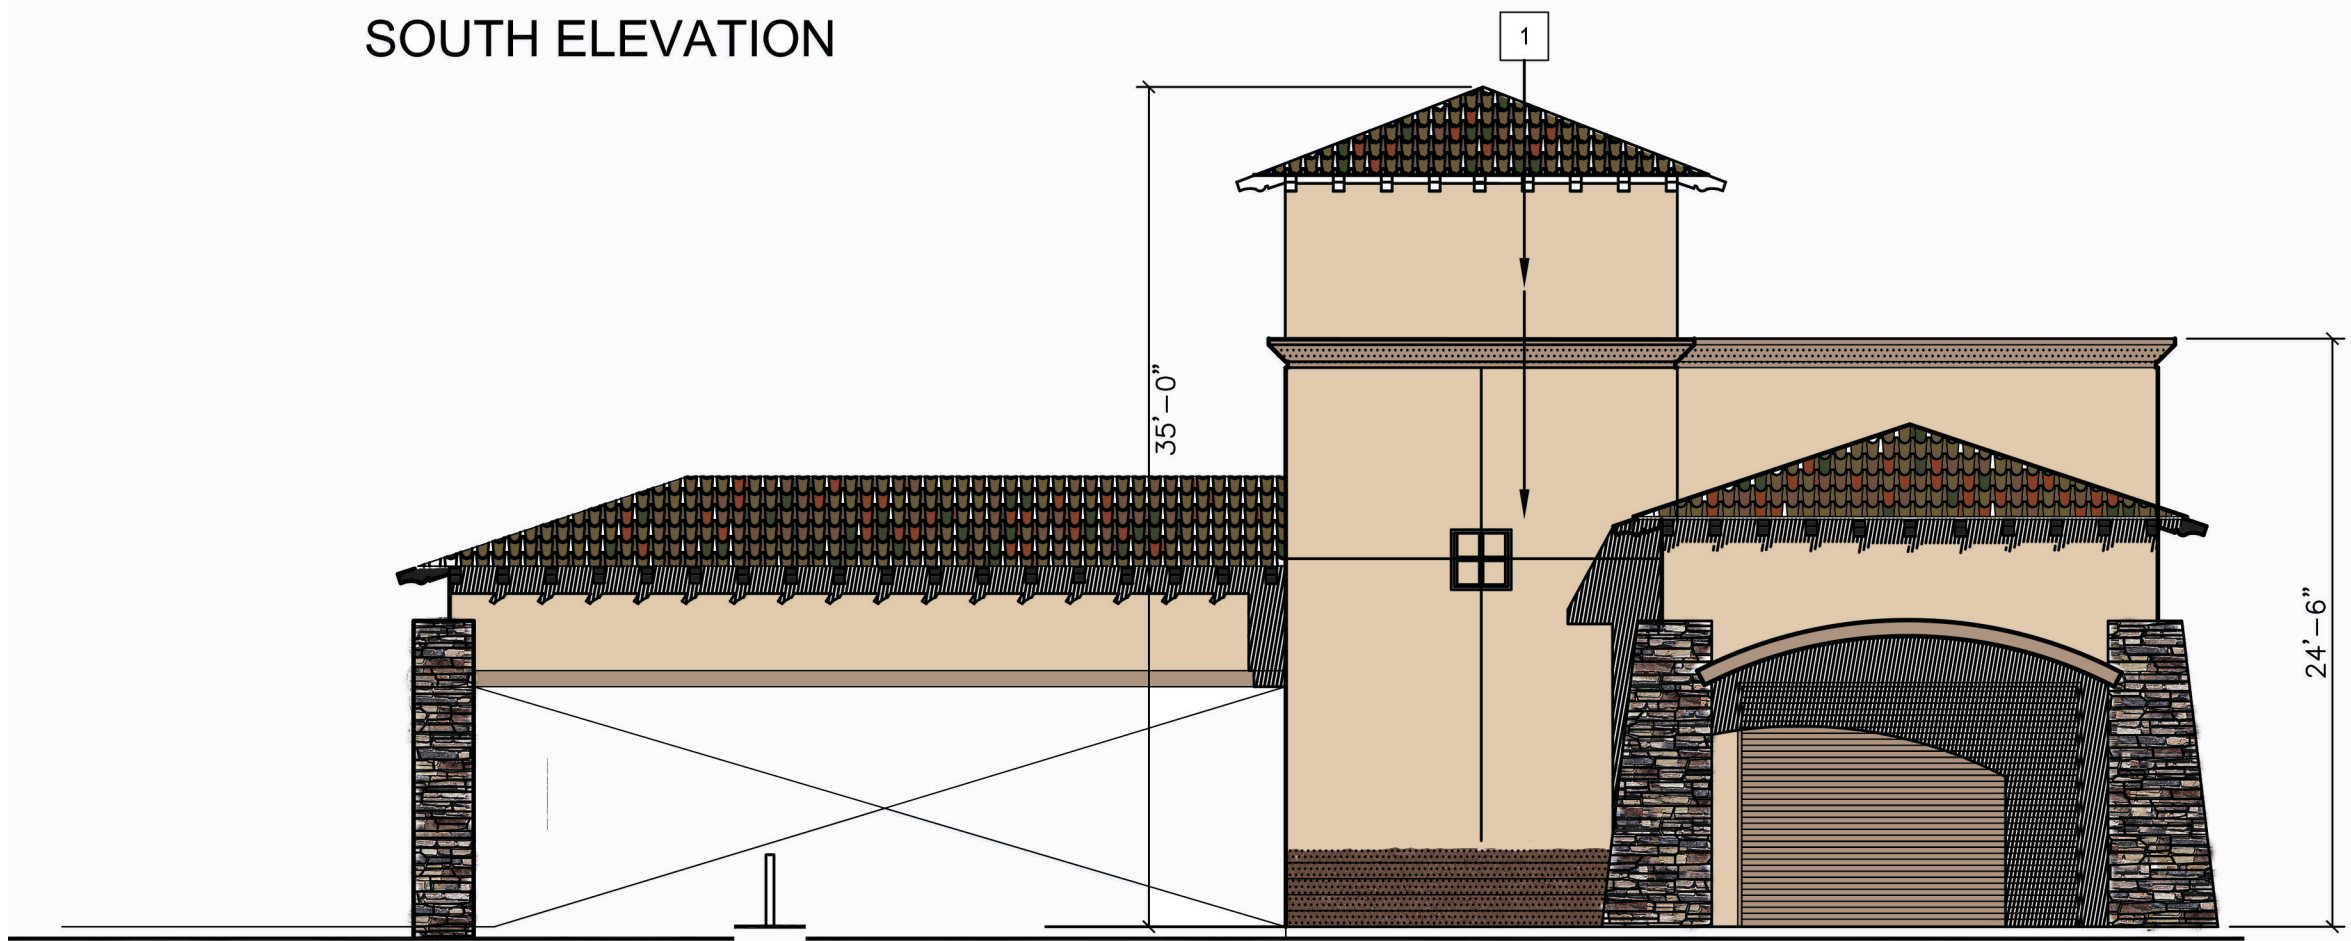

WEST ELEVATION

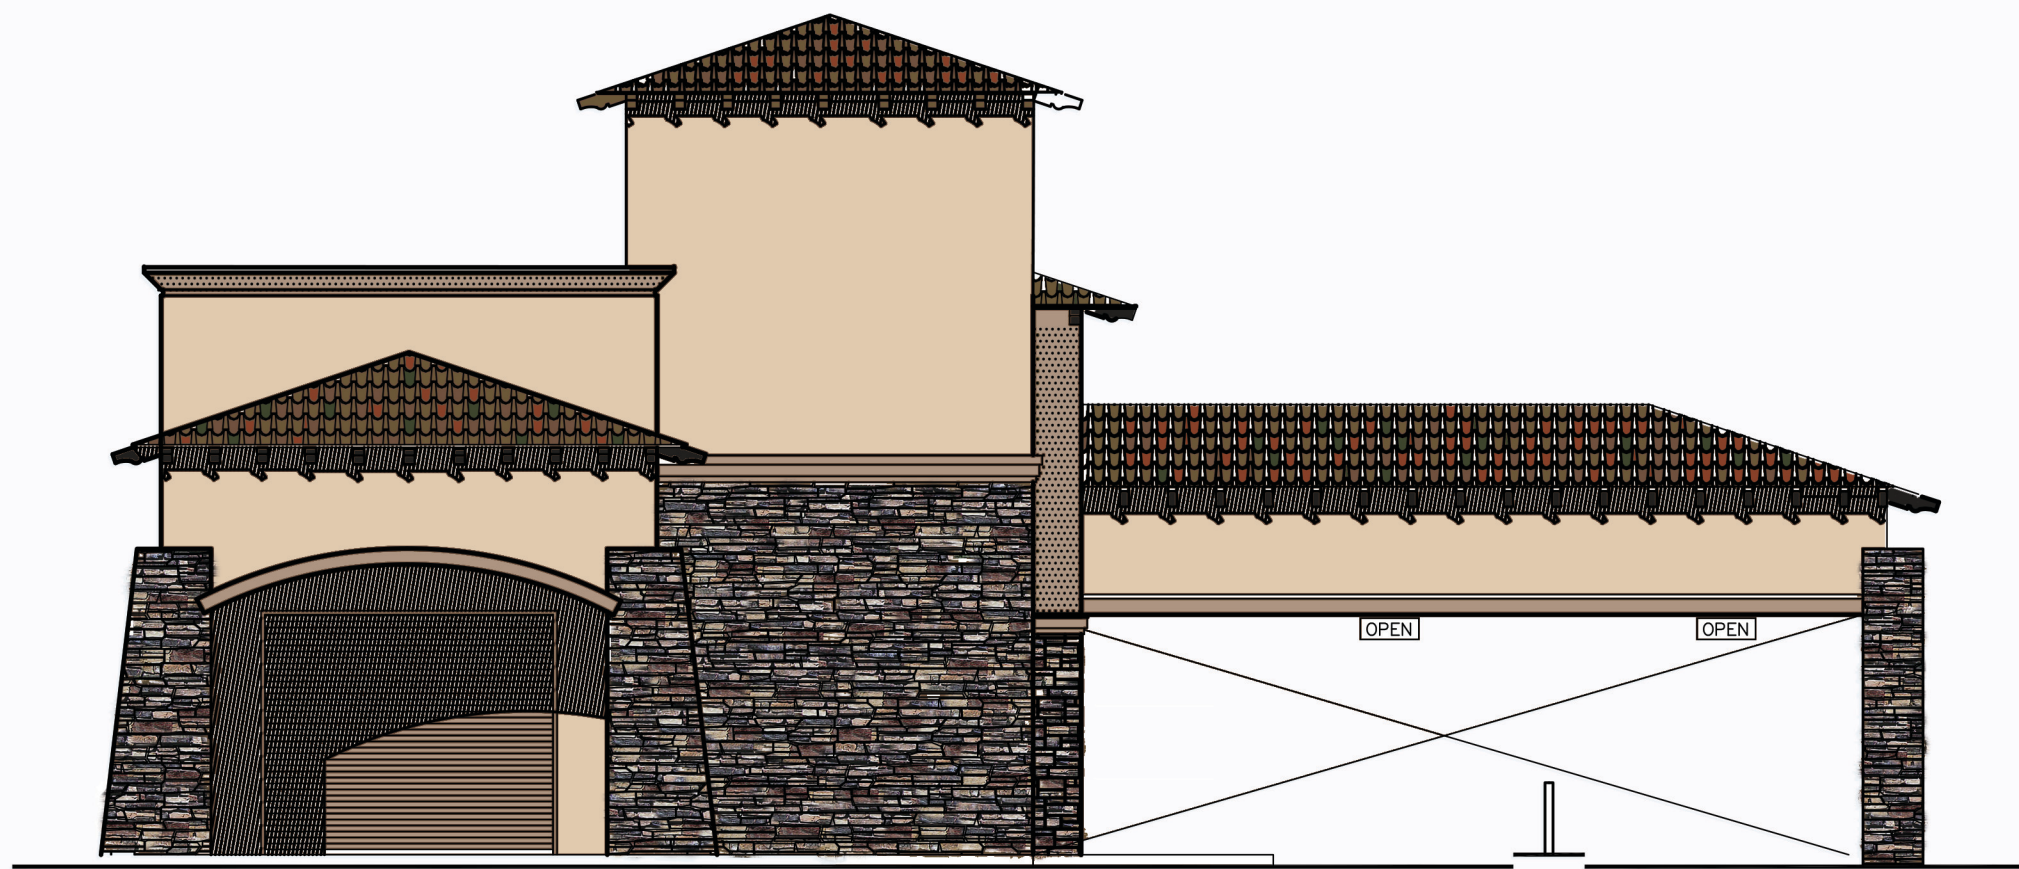

EAST ELEVATION

ARCHITECTURAL EXTERIOR ELEVATIONS

1/8"

Keynotes

- 3 LOOP BIKE RACK, - " RIBBON BIKE RACK, # RB 05"
- 6" PIPE BOLLARD SEE DETAIL 17 / A1.1
- CMU WALL - (CAPITOL PRODUCTS) SEE STRUCTURAL
- STONE VENEER.
- STANDING SEAM MTL. ROOFING OVER 2 LAYERS 30# ROOFERS FELT
- 4" ABS. DRAIN TO DAYLIGHT THRU CURB SEE DETAIL 18 / A 1.1
- 4" ABS. OVERFLOW DRAIN TO DAYLIGHT + 10'-0" A.F.F. 17 / A 8.0
- 6" SHT. MTL. RAIN GUTTER AND DOWN SPOUT
- MTL. ROLL UP DOOR SEE SHEET A 7.0
- EXTERIOR ALUM. FRAMED STOREFRONT SYSTEM W/ DARK BRONZE FRAME / DUAL VANDAL RESISTANT GLAZING
- 4'-0"X5'-4" ALUM. STOREFRONT WINDOW W. DARK BRONZE FRAME / DUAL VANDAL RESISTANT GLAZING W/ INTERIOR MIRROR TINTS SEE DETAILS X / A8.7
- 4'-0"X5'-4" ALUM. STOREFRONT WINDOW W. DARK BRONZE FRAME / DUAL VANDAL RESISTANT GLAZING SEE DETAILS X / A8.7
- ALUM. STOREFRONT W/ DARK BRONZE FRAME/ DUAL VANDAL RESISTANT SPANDREL GLAZING OBGURE
- INTERIOR ALUM. STORE FRONT SYSTEM, DARK BRONZE W/ DUAL CLEAR GLAZING, SEE PLANS FOR TEMPERED GLASS LOCATIONS
- PINEAPPLE GROVE "24SM-035" - COSTAL IVORY 14 / A 8.0
- FRY REVEAL, PCS-75-50
- FRY REVEAL, PCS-75-25
- 7/8" EXTERIOR CEMENT PLASTER W/ OMEGA 44 ELASTOMERIC FINISH.
- 3/4" EXTERIOR CEMENT PLASTER FINISH OVER HIGH-RIB MTL. LATH
- 16" X 16" HEAVY DUTY LOUVERED VENT MOUNTED @ + 8' A.F.F. SEE DETAIL 3/ A8.1
- CARWASH SIGNAGE - UNDER SEPARATE REVIEW AND PERMIT
- STAINLESS STEEL CABLE TRELLIS , SEE DETAIL X / A 8.1
- TACTILE RESTROOM SIGNAGE SEE DETAIL 12/ G1.4
- WASH SINK, SEE PLUMING PLANS
- MAIN PANEL, SEE ELECTRICAL PLANS

Exterior Finish Schedule

1	7/8" EXTERIOR CEMENT PLASTER W/ ELASTOMERIC TOP COAT - FIELD	DUNN EDWARDS DEC738 TRAVERTINE LRV 55
2	7/8" EXTERIOR CEMENT PLASTER W/ ELASTOMERIC TOP COAT - ACCENT	DUNN EDWARDSA DEB075 WOODLAKE LRV 24
3	STONE VENEER	VISTOSO STONE 'A'
4	CONCRETE BLOCK- SMOOTH	SUPERLITE - HARVEST BROWN
5	CONCRETE BLOCK - SPLIT FACE	SUPERLITE - HARVEST BROWN
6	TILE ROOFING	M.C.A. OLD SAGUARO BLEND
7		
8	STORE FRONT & GLAZING	DARK BRONZE ANODIZED FRAMES, WITH DUAL VANDAL RESISTANT DBL. ONE WAY CLEAR GLAZING
9	STORE FRONT & GLAZING	DARK BRONZE ANODIZED FRAMES, WITH DUAL VANDAL RESISTANT SPANDREL OBGURE GLAZING
10	PARAPET CAP	DUNN EDWARDSA DEB075 WOODLAKE LRV 24
11	DOOR SEE SCHEDULE	PAINT TO MATCH ADJACENT SURFACE
12	EXPOSED WOOD RAFTER TAILS	DUNN EDWARDSA DEB014 DARK CHOCOLATE LRV 7
13	CEMENT PLASTER FASCIA	DUNN EDWARDSA DEB075 WOODLAKE LRV 24
14		
15	VACUUM CANOPY - SOLOR PANELS BY SOLAR INSTALLER	DUNN EDWARDS DEC738 TRAVERTINE LRV 55
16	STORE FRONT & GLAZING	DARK BRONZE ANODIZED FRAMES, WITH DUAL VANDAL RESISTANT DBL. CLEAR GLAZING

DATE 4/5/2020

REV. 10/13/22

SHEET NO.

A.3.0
ARCHITETURAL
ELEVATIONS